
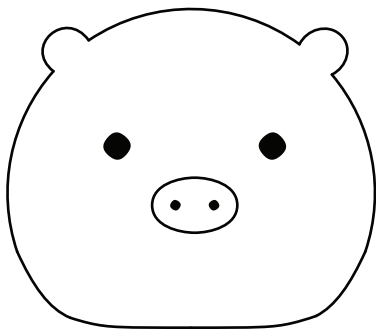


IVAN WEST FU

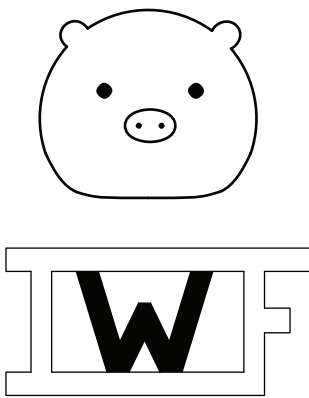


PIGGY WHISKEY BAR


 



PROJECT NAME: PIGGY WISKEY BAR
DRAWINGS BY: YIHENG FU(WEST)
PERSONAL ACCOUNT:12096588
LOCATION: UTS DAB FACULTY LV. 4




IVAN WEST FU

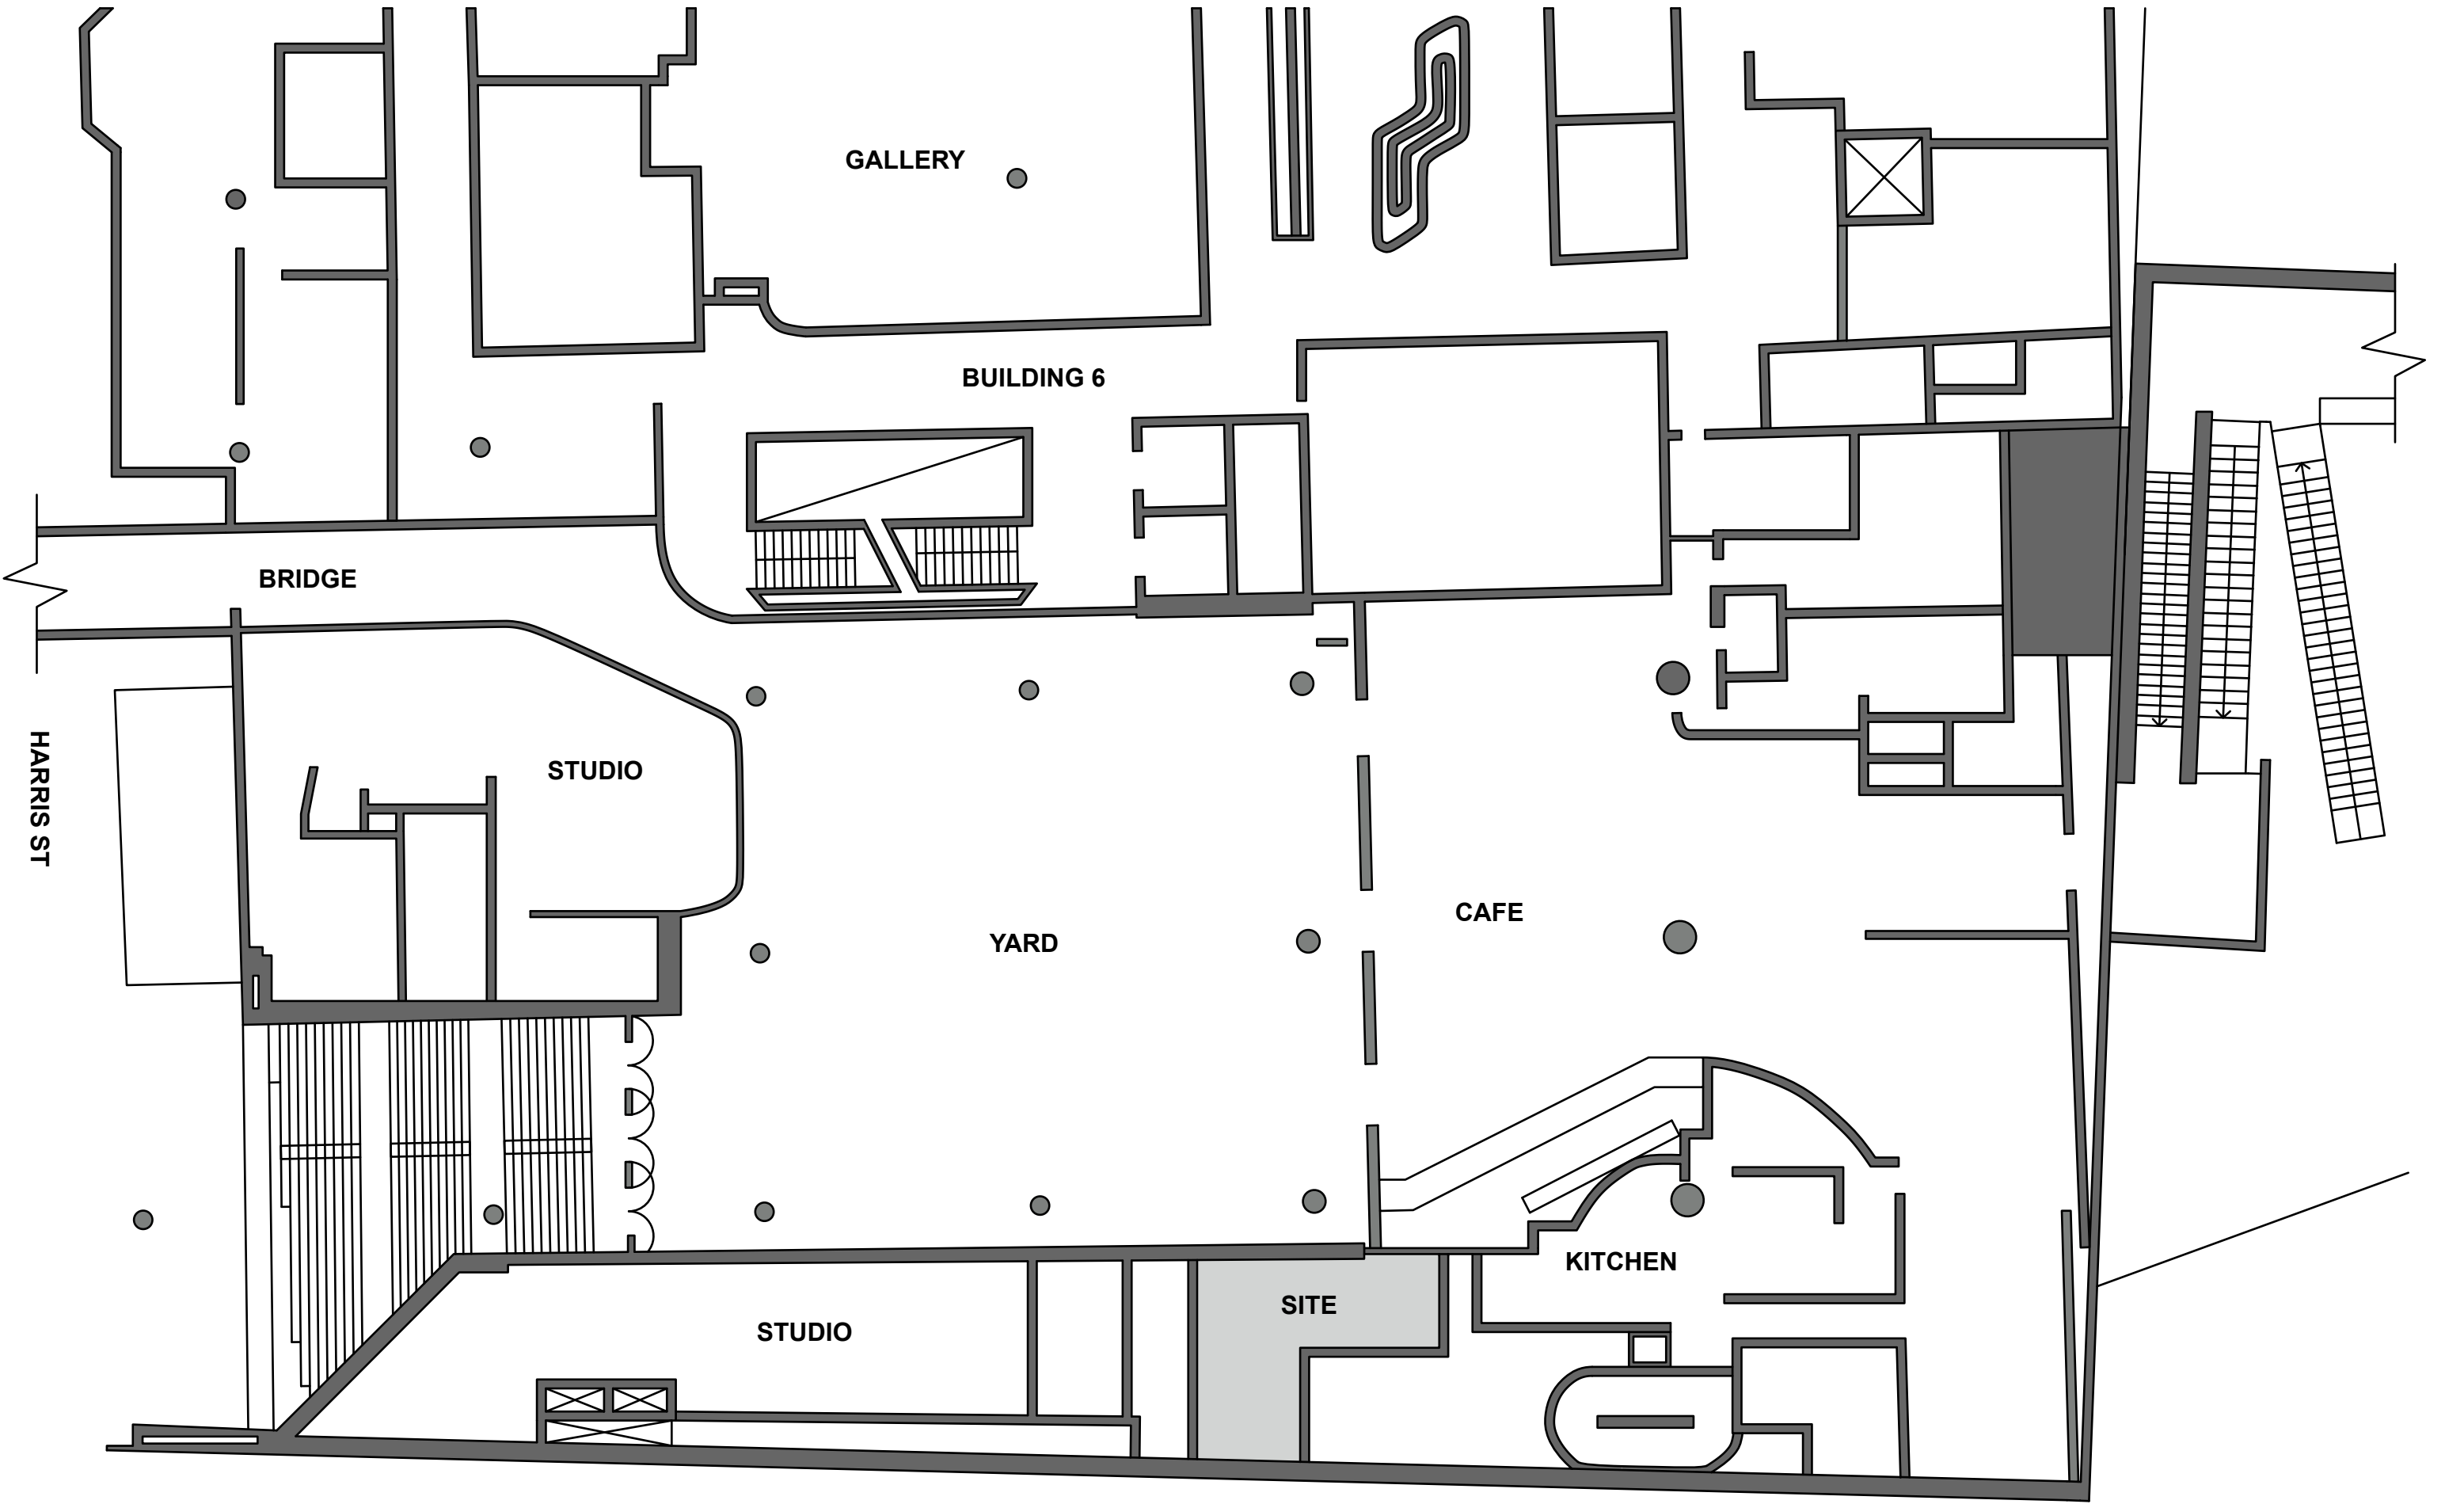DRAWING CODE	TITLE	SCALE
A100	SITE PLAN	1:200
A101	FLOOR PLAN	1:50
A102	REFLECTED CEILING PLAN	1:50
A103	LIGHTING PLAN	1:50
A104	DATA&ELECTRICAL PLAN	1:50
A200	FACADE	1:50
A201	SECTIONS	1:50
A202	ELEVATIONS	1:50
A300	DETAILED JOINERY 01	1:20/1:5
A301	DETAILED JOINERY 02	1:20/1:5
A302	DETAILED JOINERY 03	1:20/1:5
A303	CUSTOM FEATURES	1:5
A400	MATERIAL SCHEDULE	
A401	FURNITURE SCHEDULE	
A402	LIGHTING SCHEDULE	



 UTS UNIVERSITY OF TECHNOLOGY SYDNEY	SITE ADDRESS: 704-730 HARRIS St, ULTIMO, NSW 2007	DIRECTION: 		REV	DESCRIPTION	BY	GENERAL NOTES <small>ALL DIMENSIONS AND EXISTING CONDITIONS MUST BE CHECKED AND VERIFIED BY THE CONTRACTOR BEFORE PROCEEDING WITH THE WORK. DO NOT SCALE DRAWINGS, USE DIMENSION AS PROVIDED</small>	 Ivan West Fu	WHISKEY BAR		
		A	ISSUE FOR REVIEW	YIHENG FU	DRAWN BY:	SCALE:			DRAWING TYPE:	REV.	SHEET NO.
		B	ISSUE FOR TENDER	YIHENG FU	YIHENG FU(WEST)	1:200			SITE PLAN		
		GENERAL LEGENDS  SITE  WALL		PROVIDED BY:		PAPER SIZE:	DATE:	A 100			
		YIHENG FU(WEST)		A3	26 AUG 2018						

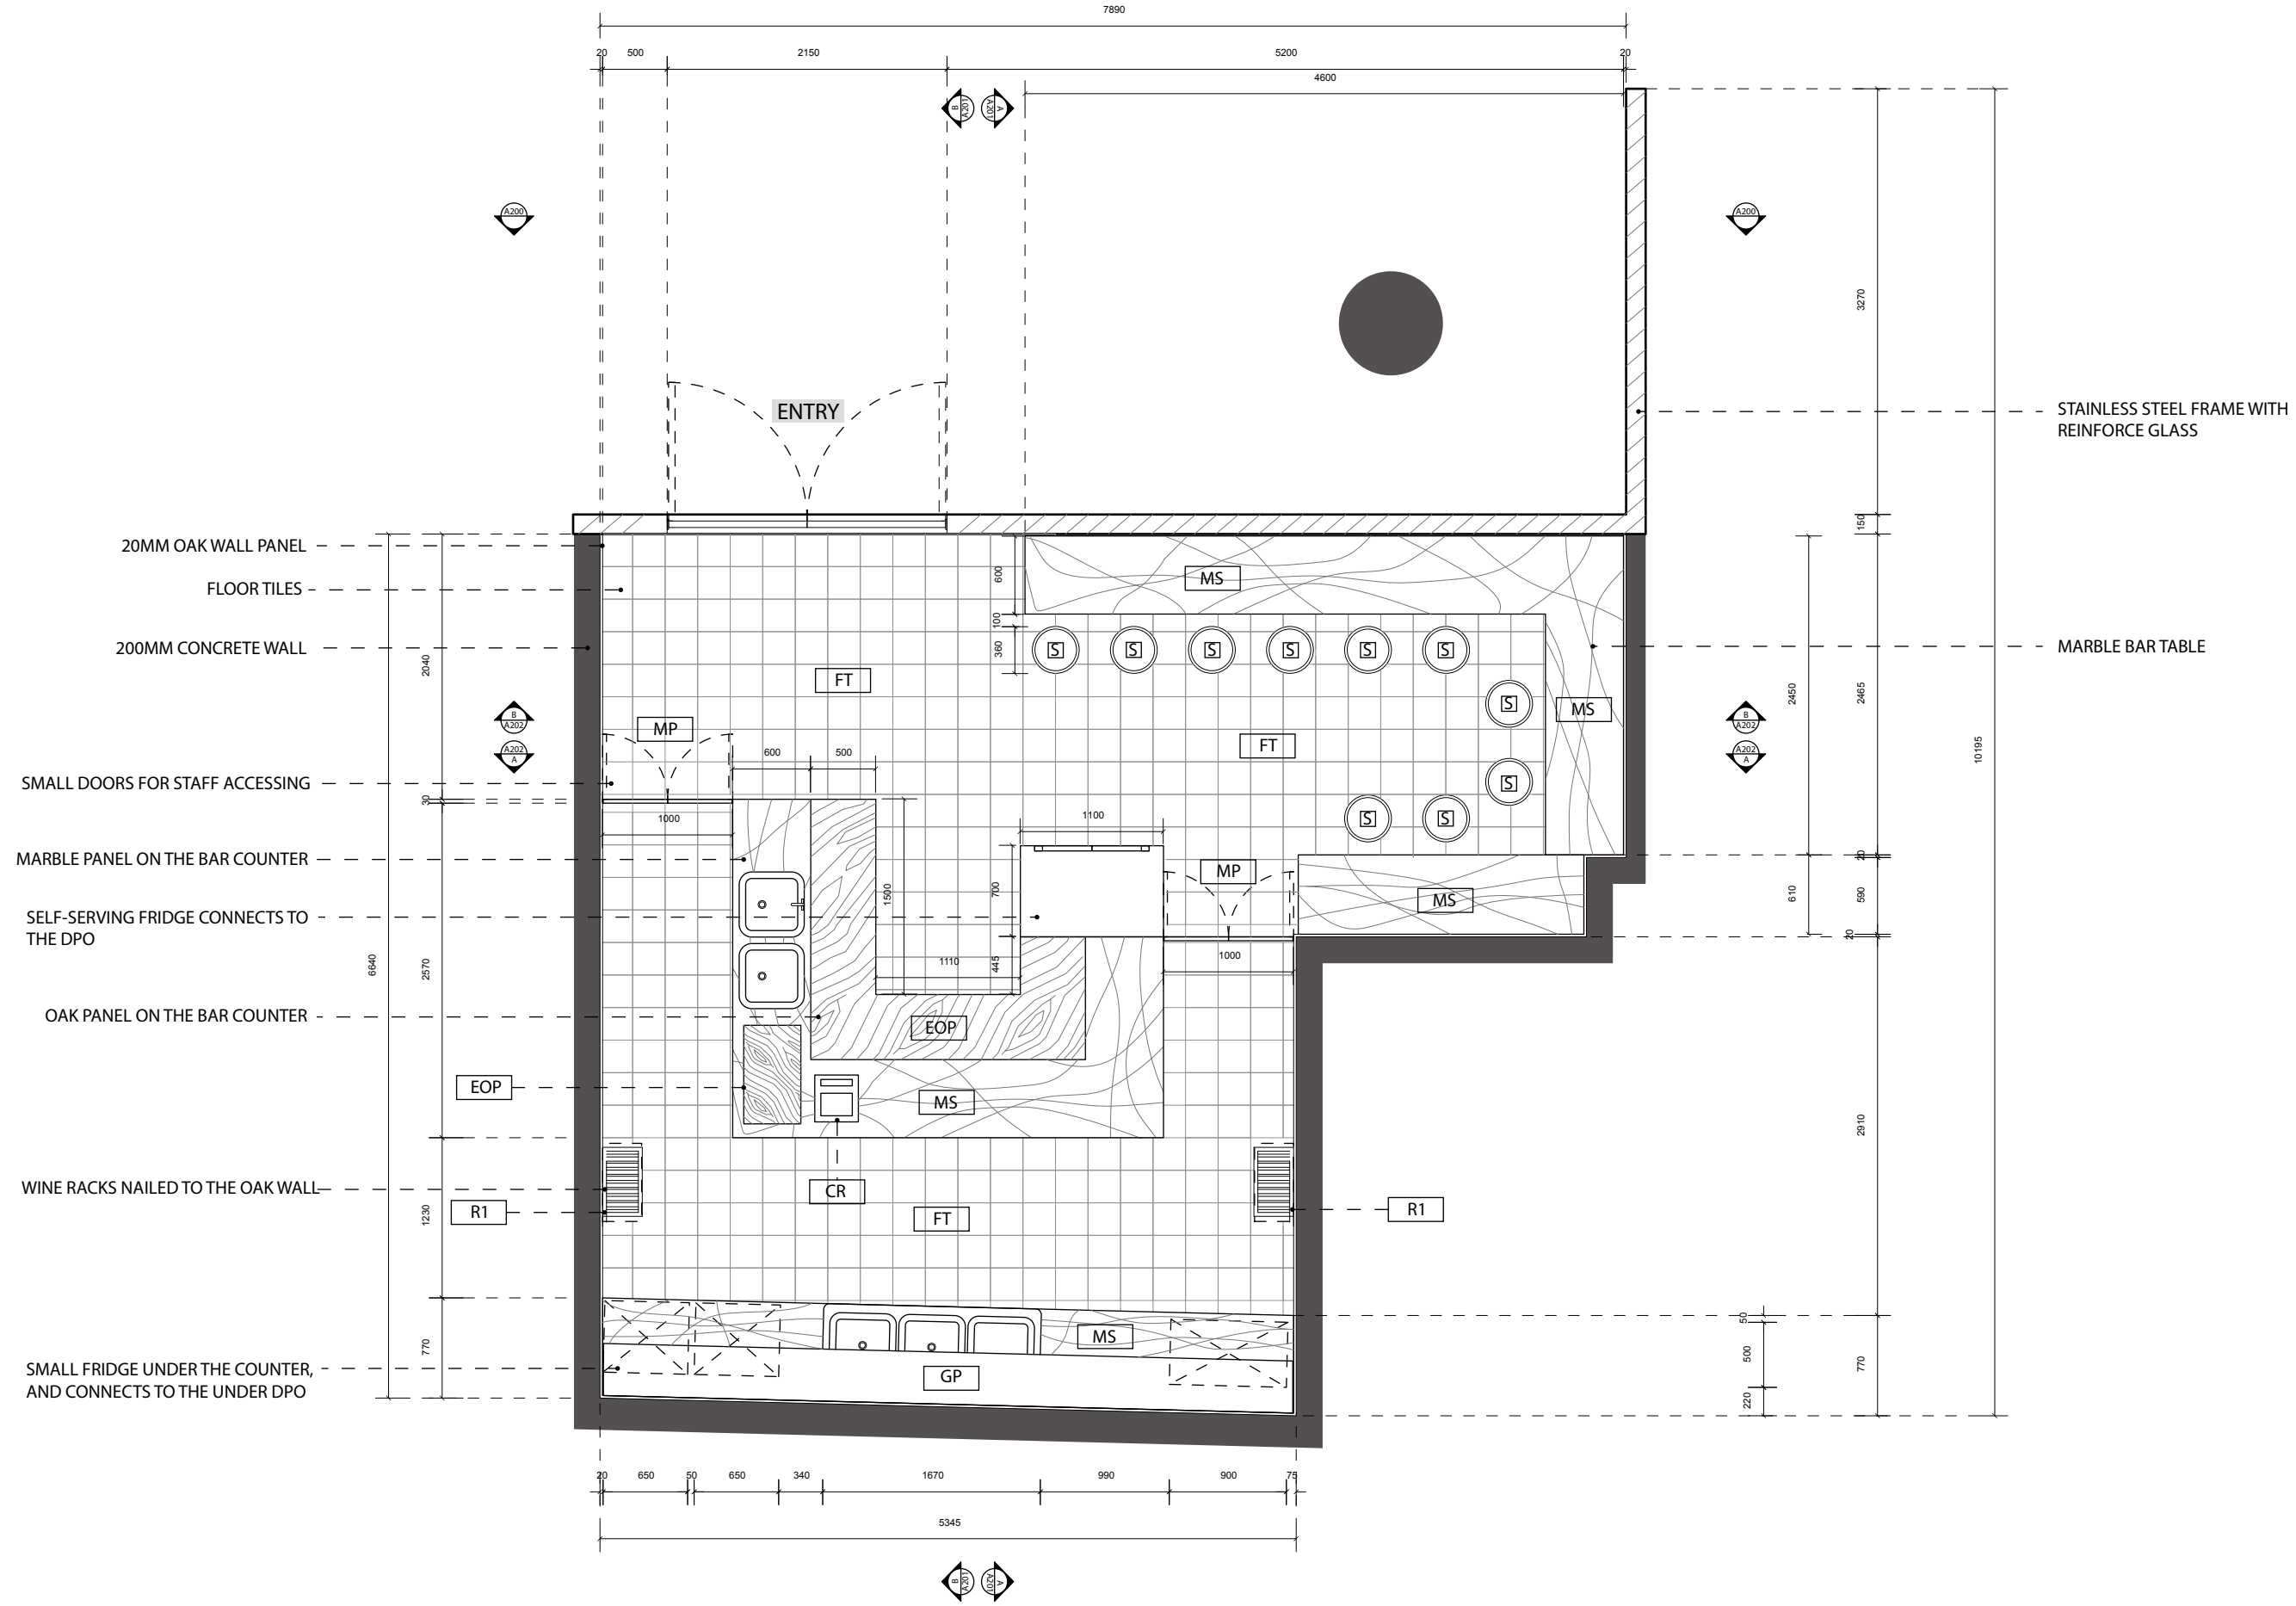




 
20MM OAK WALL PANEL
FLOOR TILES
200MM CONCRETE WALL
SMALL DOORS FOR STAFF ACCESSING
MARBLE PANEL ON THE BAR COUNTER
SELF-SERVING FRIDGE CONNECTS TO THE DPO
OAK PANEL ON THE BAR COUNTER
WINE RACKS NAILED TO THE OAK WALL
SMALL FRIDGE UNDER THE COUNTER, AND CONNECTS TO THE UNDER DPO

STAINLESS STEEL FRAME WITH REINFORCE GLASS
MARBLE BAR TABLE




SITE ADDRESS:
704-730 HARRIS St,
ULTIMO, NSW 2007

GENERAL LEGENDS	
	OAK
	STEEL
	WALL

	TILES
---	-------


REV	DESCRIPTION	BY
A	ISSUE FOR REVIEW	YIHENG FU
B	ISSUE FOR TENDER	YIHENG FU

GENERAL NOTES
ALL DIMENSIONS AND EXISTING CONDITIONS MUST BE CHECKED AND VERIFIED BY THE CONTRACTOR BEFORE PROCEEDING WITH THE WORK.
DO NOT SCALE DRAWINGS, USE DIMENSION AS PROVIDED

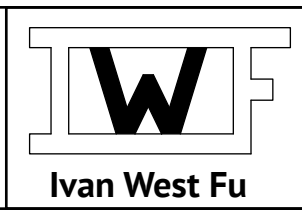



WHISKEY BAR

DRAWN BY: YIHENG FU(WEST)	SCALE: 1:50	DRAWING TYPE: FLOOR PLAN	REV.	SHEET NO.
PROVIDED BY: YIHENG FU(WEST)	PAPER SIZE: A3	DATE: 07 OCT 2018		A 101

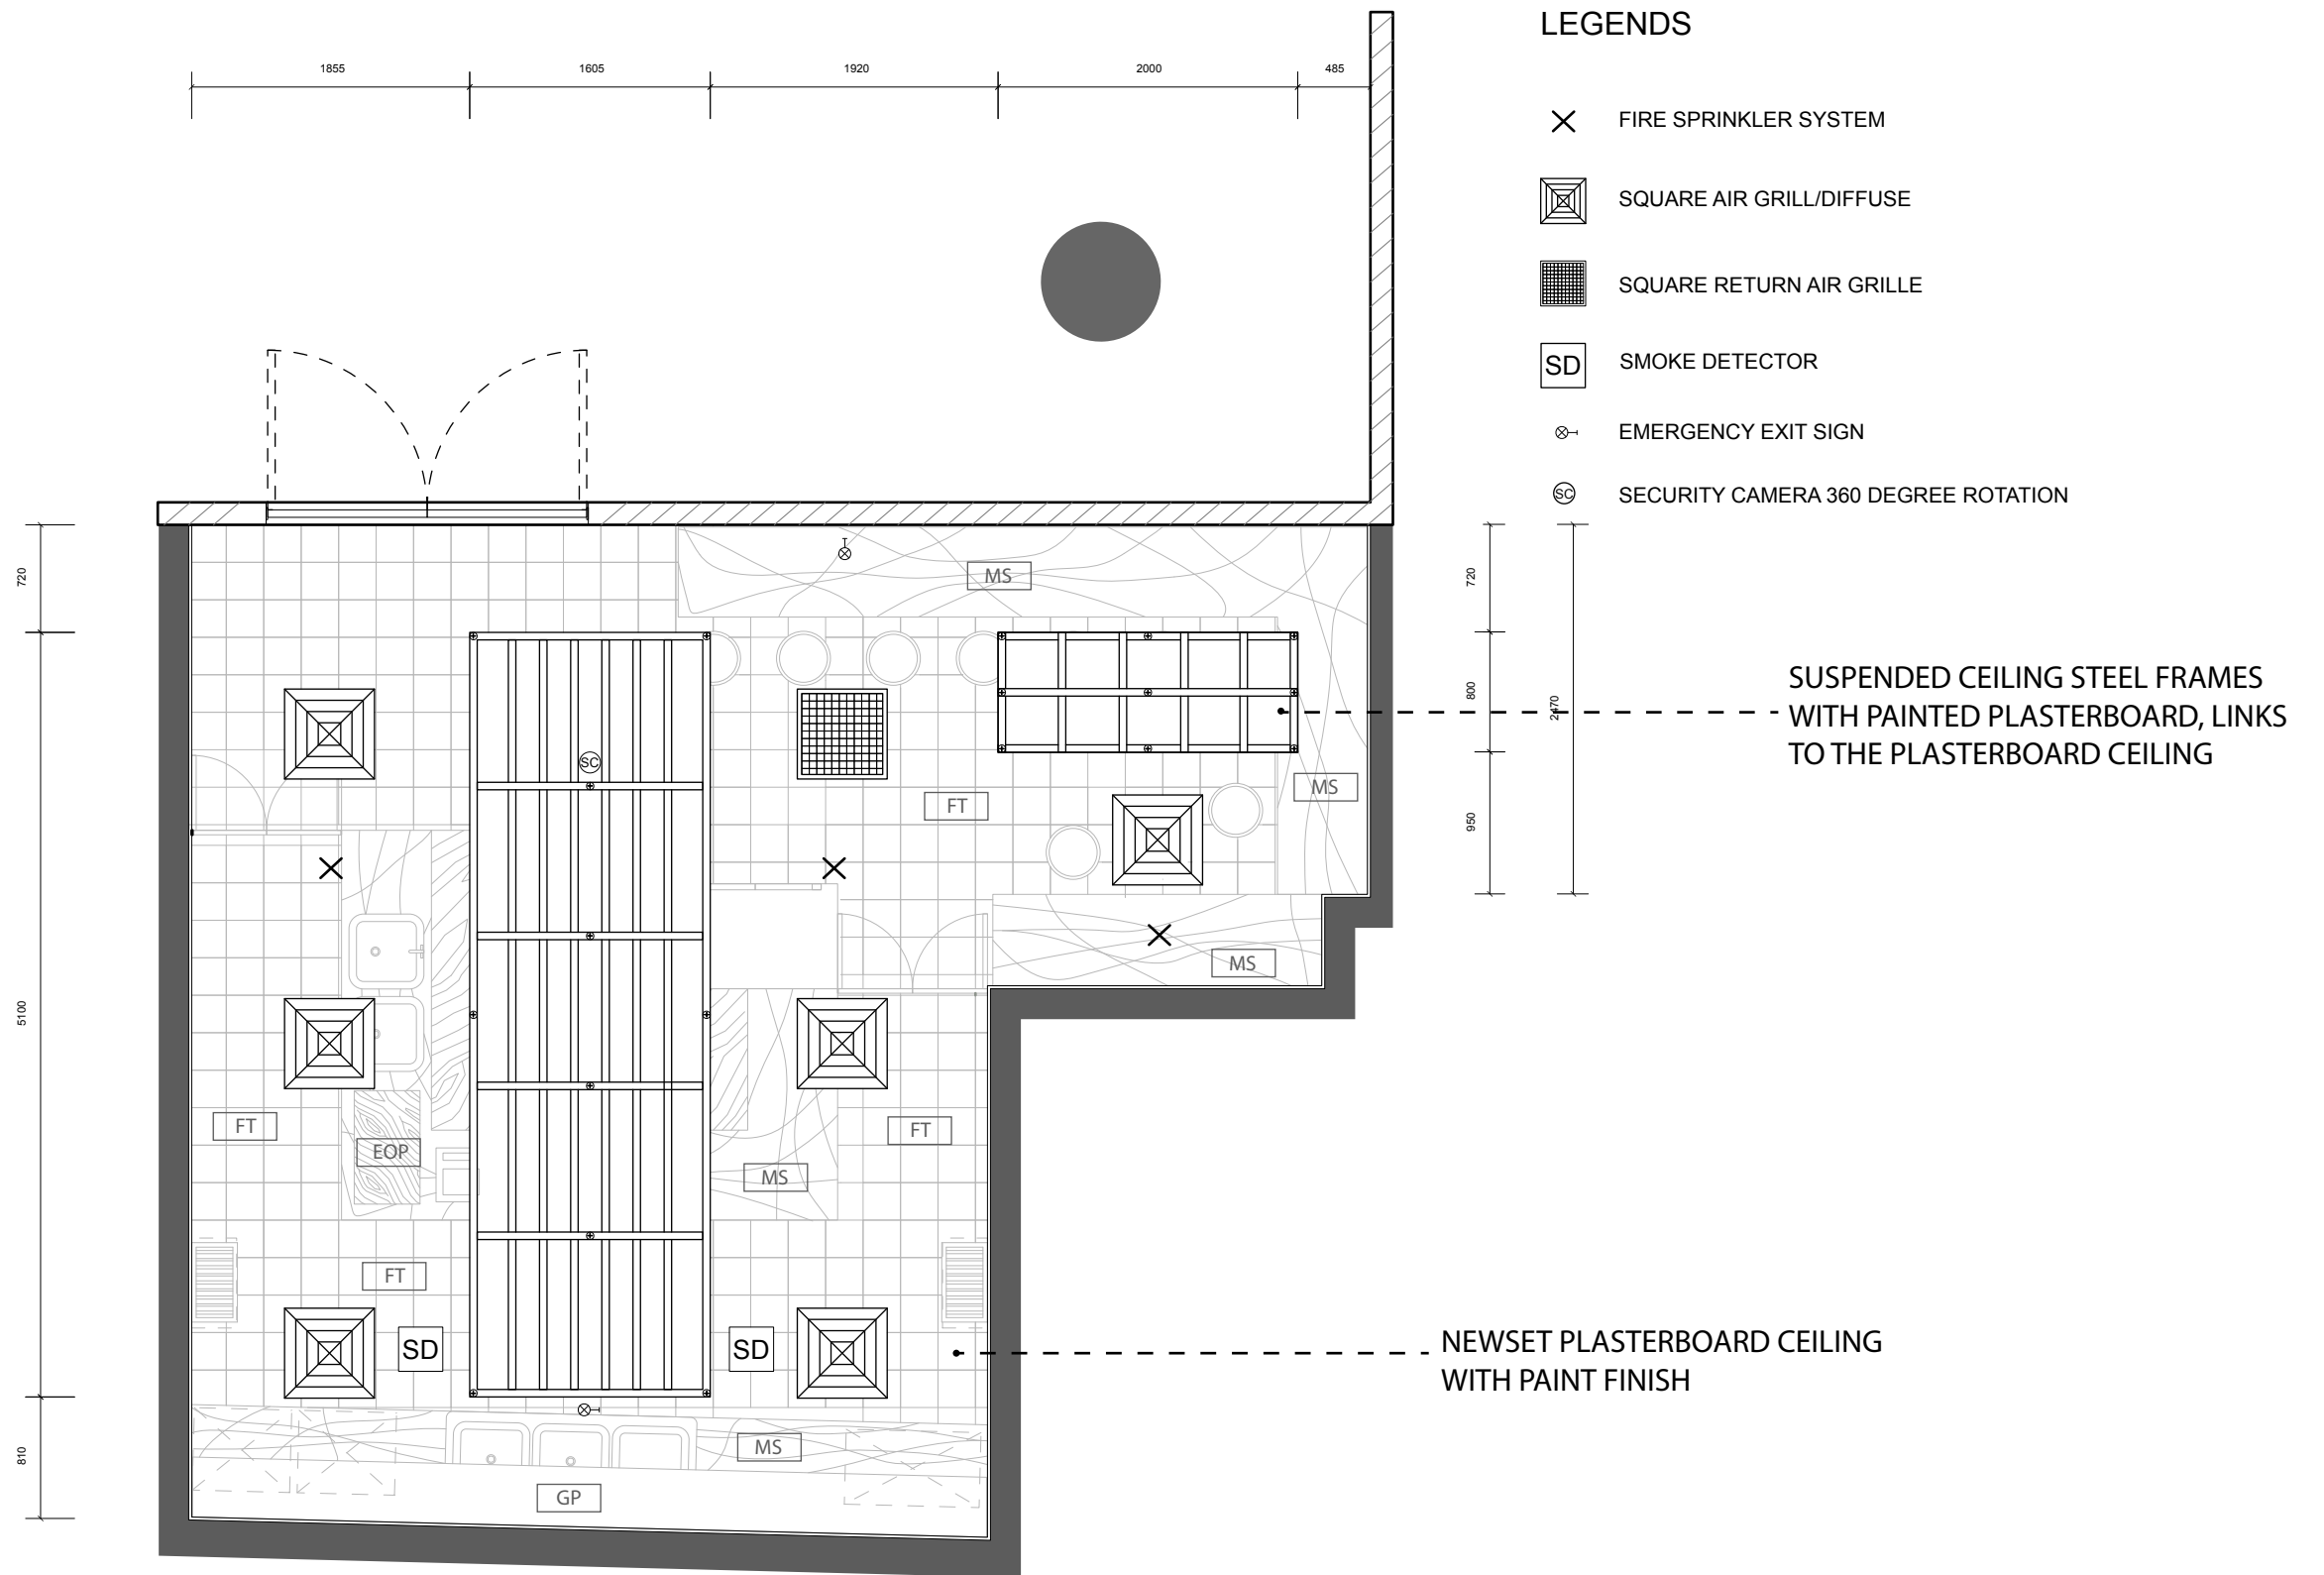

GENERAL LEGENDS

  STEEL
 WALL

REV

A
B


DESCRIPTION
ISSUE FOR REVIEW
ISSUE FOR TENDER

BY
YIHENG FU
YIHENG FU

GENERAL NOTES

ALL DIMENSIONS AND EXISTING CONDITIONS
MUST BE CHECKED AND VERIFIED BY THE
CONTRACTOR BEFORE PROCEEDING WITH THE
WORK.

DO NOT SCALE DRAWINGS, USE DIMENSION AS
PROVIDED

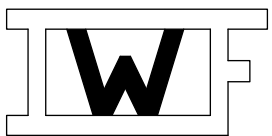

Ivan West Fu

WHISKEY BAR

DRAWN BY:
YIHENG FU(WEST)

SCALE:
1:50

DRAWING TYPE:
LIGHTING PLAN

REV. SHEET NO.

PROVIDED BY:
YIHENG FU(WEST)

PAPER SIZE:
A3

DATE:
07 OCT 2018


A 103

LEGENDS

 A1 RECESSED FULLY ADJUSTABLE DOWNLIGHT

 B TRACK MOUNTED FULLY ADJUSTABLE SPOTLIGHT FITTING


 W RECESSED WALL WASH LIGHT

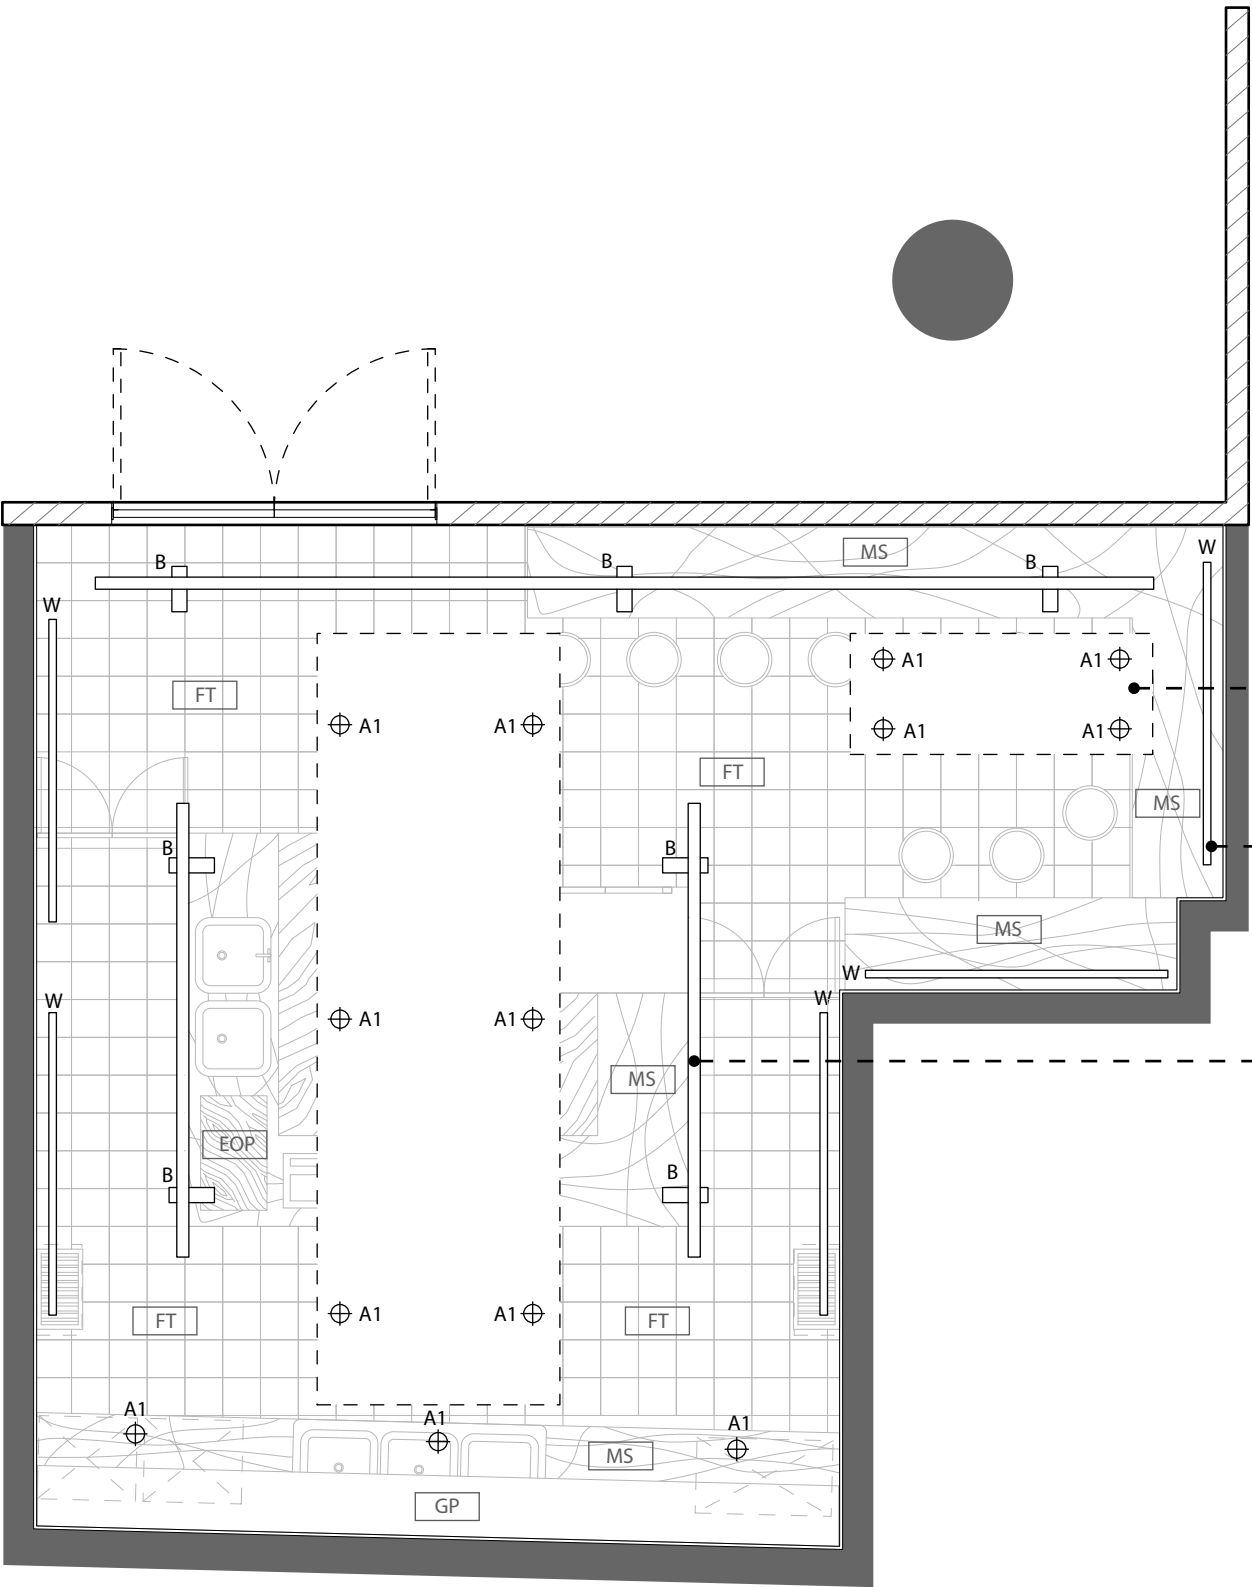





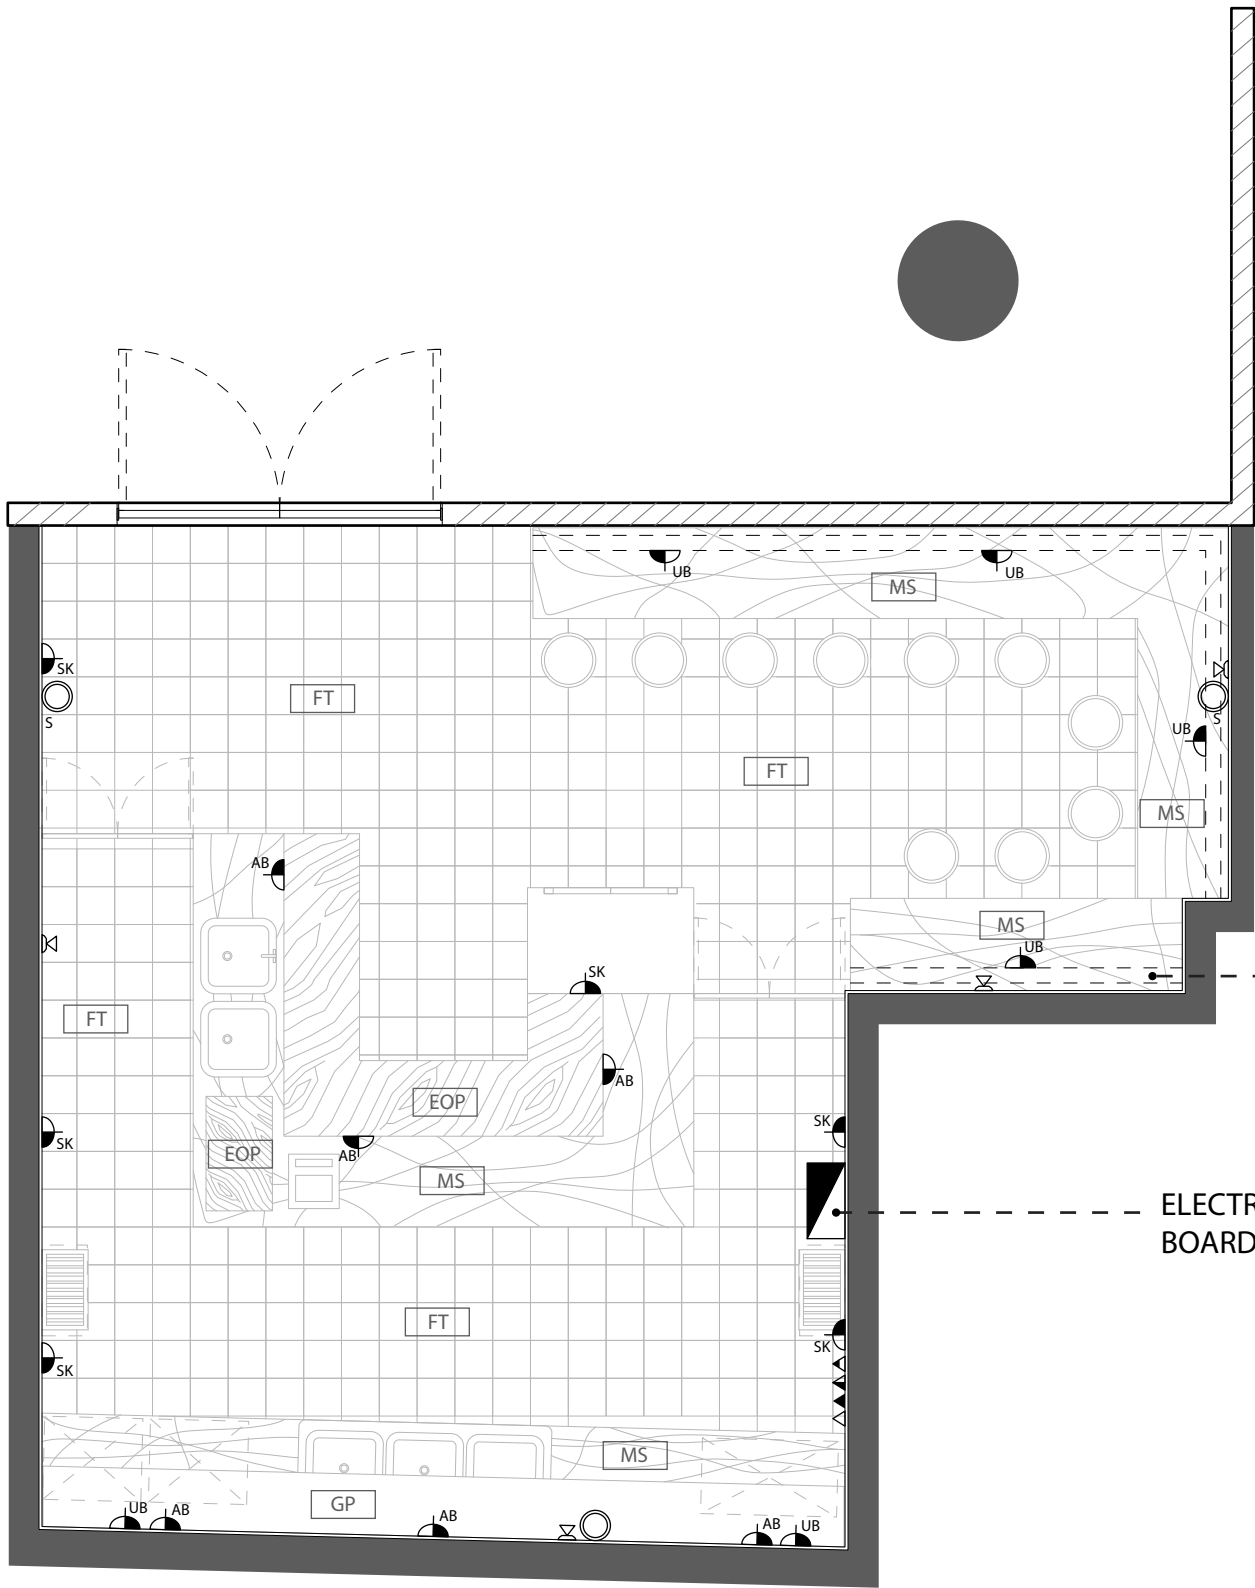


 


DOWNLIGHTS INSTALLED ON THE
PLASTERBOARD OF SUSPENDED
CEILING

WALL WASH LIGHT INSTALLED ON
PLASTERBOARD CEILING

SPOTLIGHT LIGHTS HANG ON THE
POLE



LEGENDS

-  ABOVE BENCH - DOUBLE GPO
-  UNDER BENCH - DOUBLE GPO
-  SKIRTING - DOUBLE GPO
-  TELEPHONE POINT
-  PRINT POINT
-  DATA POINT & DATA LINE INFORMATION
-  ADSL-NOTE-MUST BE LABELED AS ADSL
-  ELECTRICAL DISTRUBUTION BOARD
-  CCTV CAMERA BY SHOPFITTER
-  SPEAKER BY SHOPFITTER

WOODEN PANEL HOLDS MARBLE
PANEL, WITH DOUBLE GPO

MP

ELECTRICAL DISTRIBUTION
BOARD CONNECTS TO OAK WALL

GENERAL LEGENDS

-  STEEL
-  WALL

REV

A
B

DESCRIPTION
ISSUE FOR REVIEW
ISSUE FOR TENDER

BY
YIHENG FU
YIHENG FU

GENERAL NOTES

ALL DIMENSIONS AND EXISTING CONDITIONS
MUST BE CHECKED AND VERIFIED BY THE
CONTRACTOR BEFORE PROCEEDING WITH THE
WORK.

DO NOT SCALE DRAWINGS, USE DIMENSION AS
PROVIDED

WHISKEY BAR

DRAWN BY:
YIHENG FU(WEST)

SCALE:
1:50

DRAWING TYPE:
DATA&ELECTRICAL PLAN


REV. SHEET NO.

PROVIDED BY:
YIHENG FU(WEST)


PAPER SIZE:
A3

DATE:
07 OCT 2018


A 104

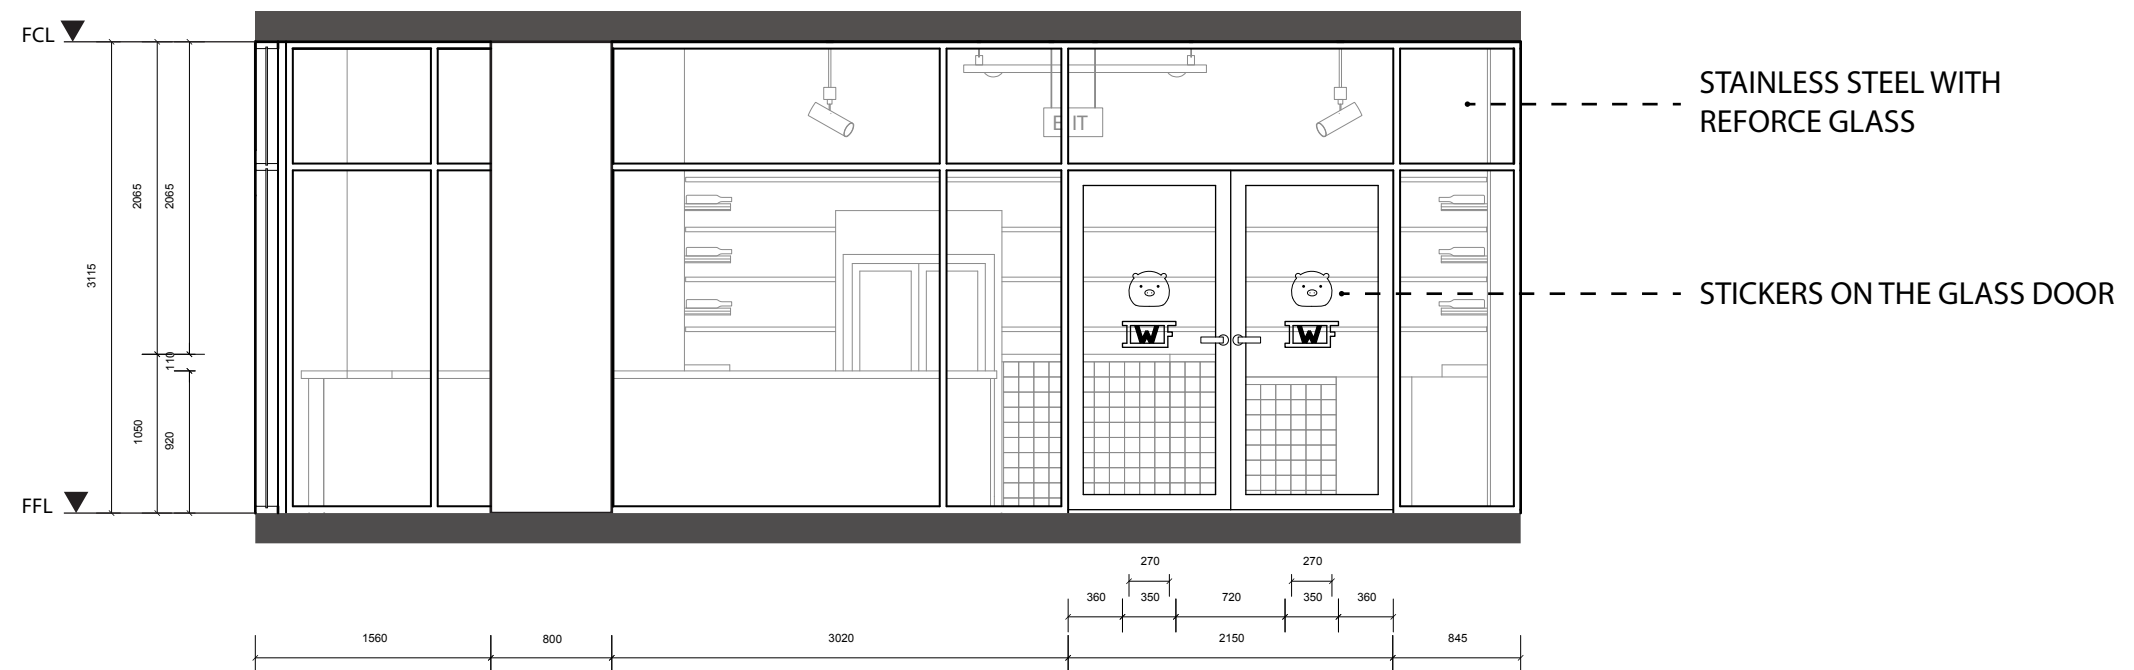


A
 A202
 FACADE
 1:50

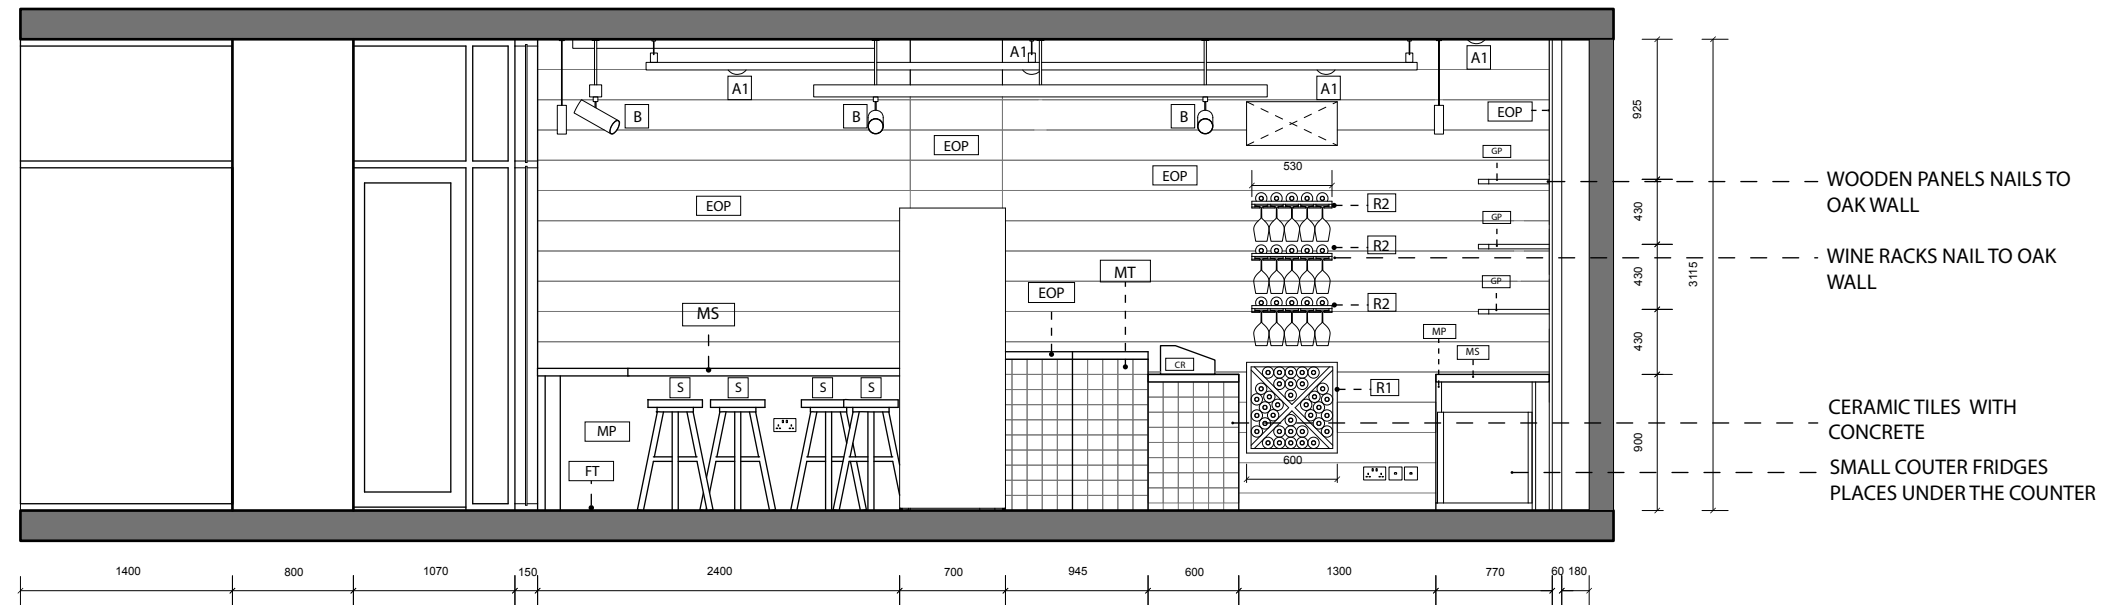


A SECTION A
A201 1:50

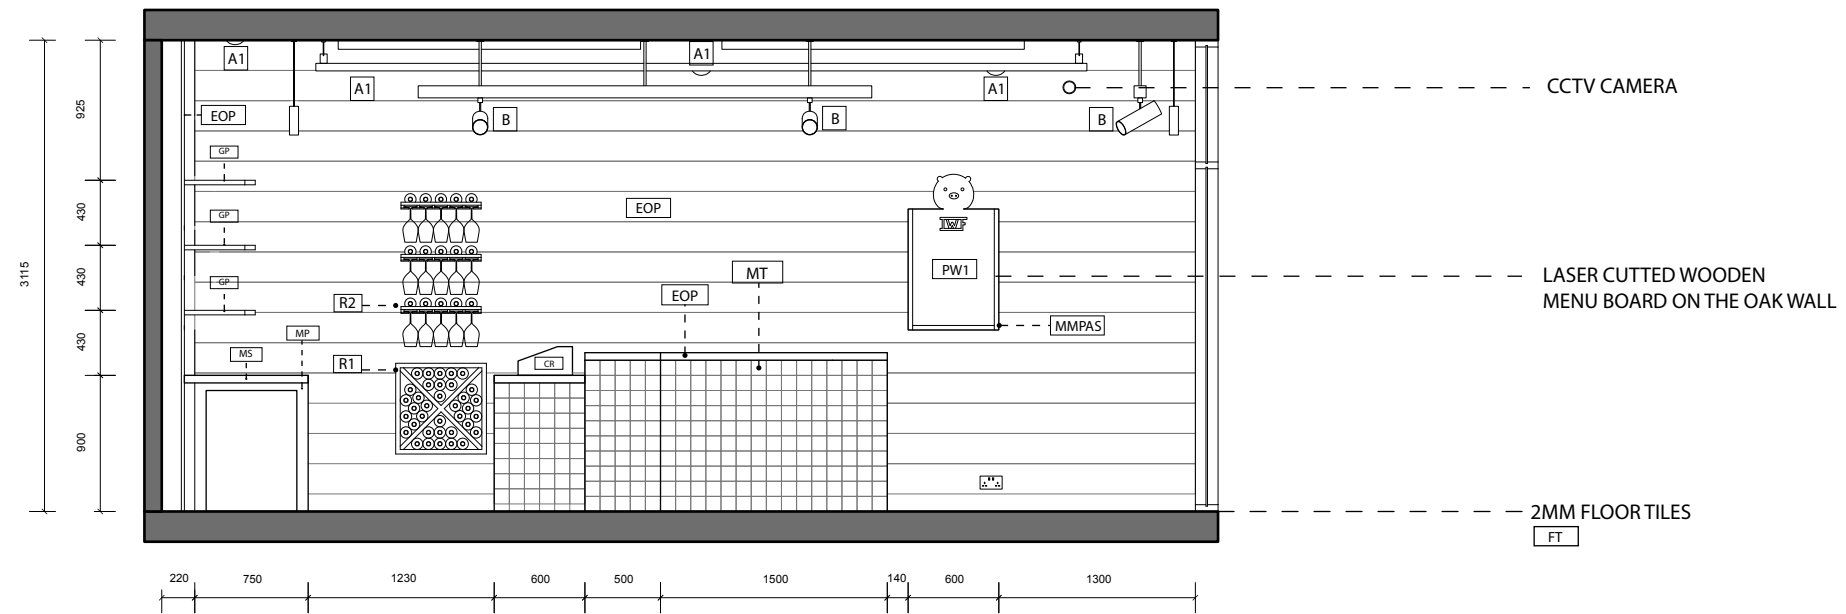


B SECTION B
A201 1:50

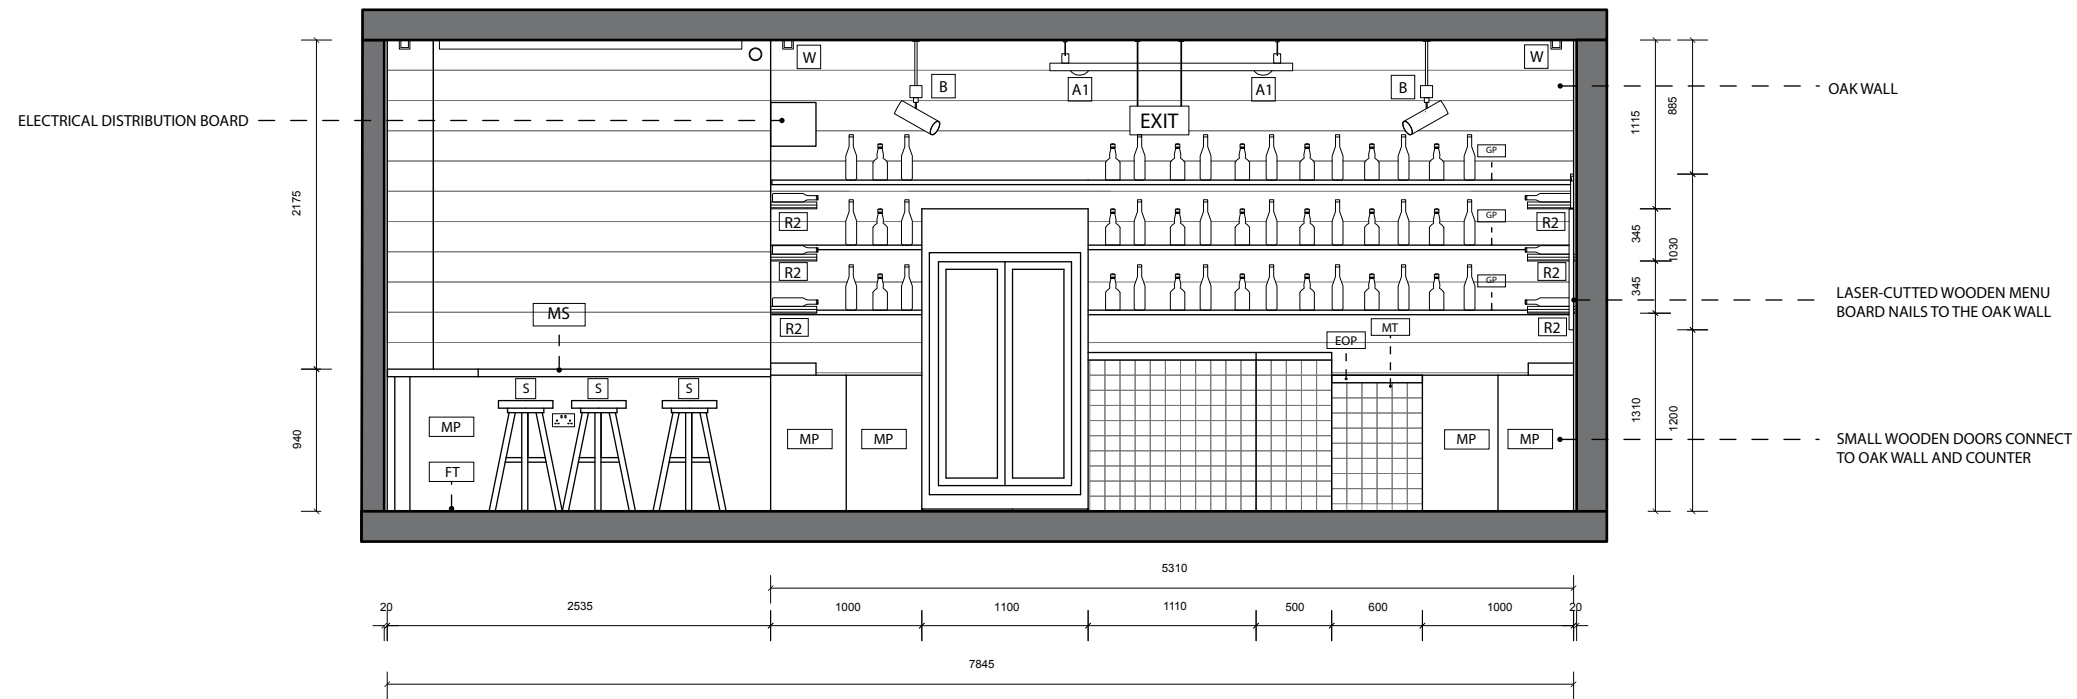


A
A202
ELEVATION A
1:50

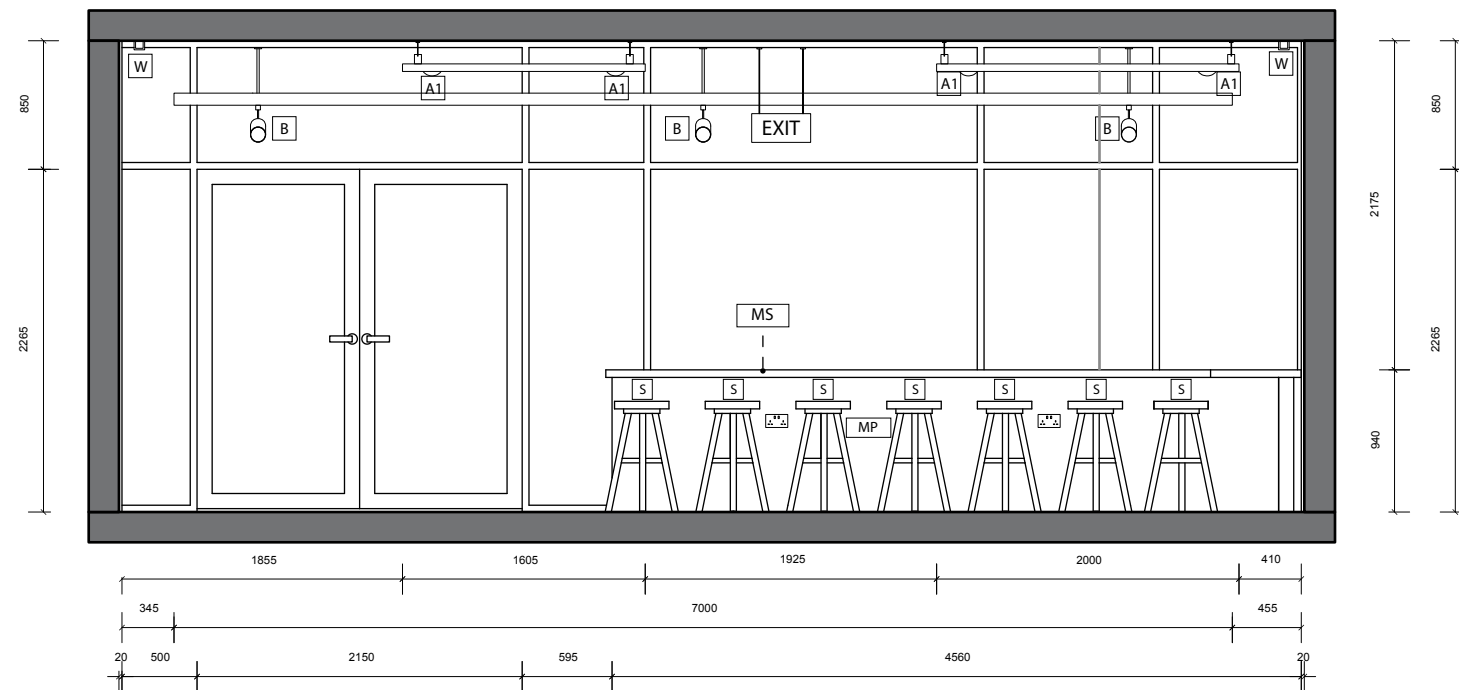


B
A202
ELEVATION B
1:50

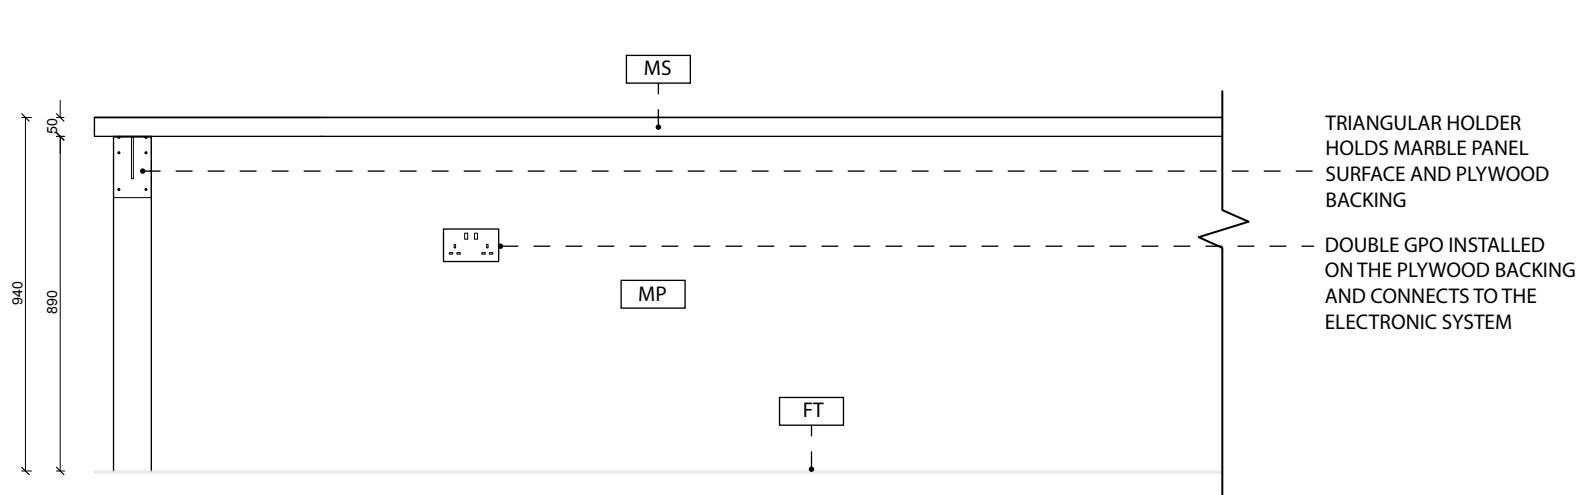


A
A300
DETAILED JOINERY 01 ELEVATION
1:20

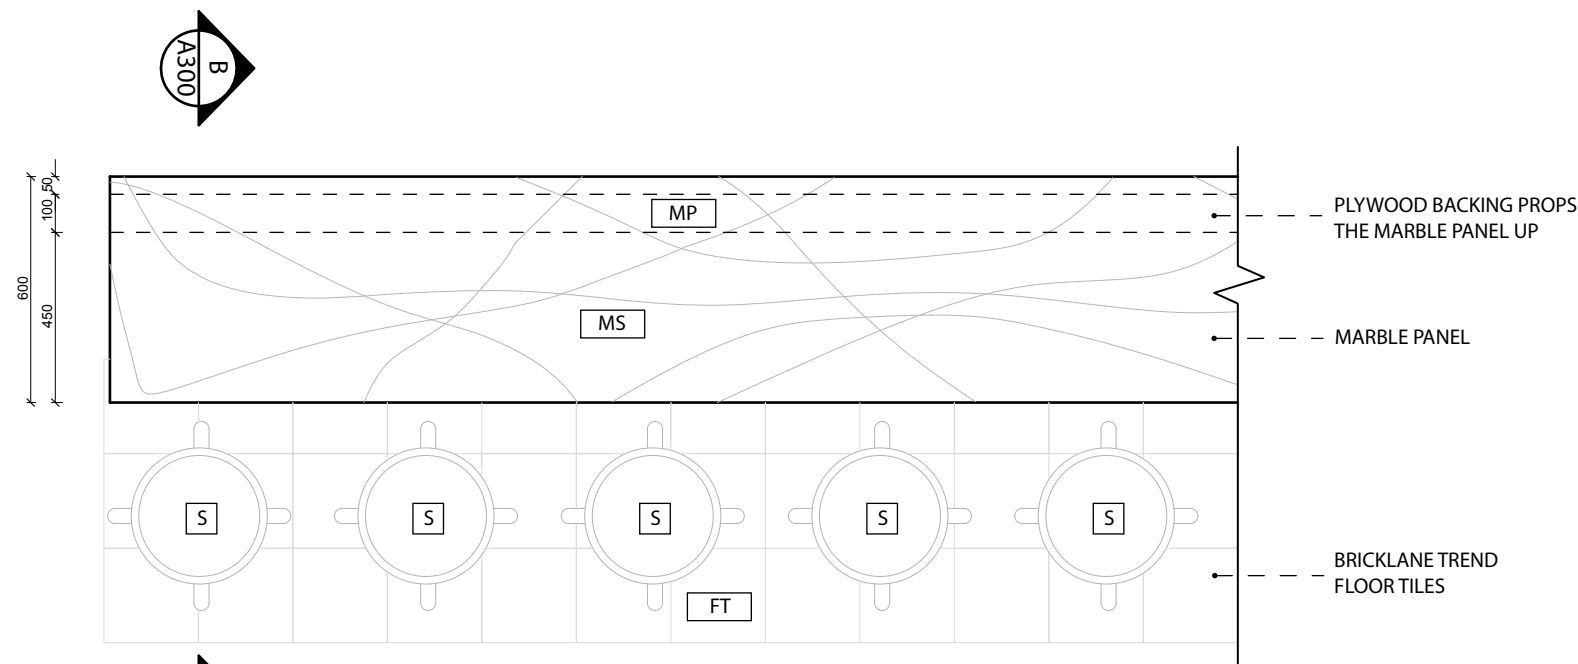


A
A300
DETAILED JOINERY 01 PLAN
1:20

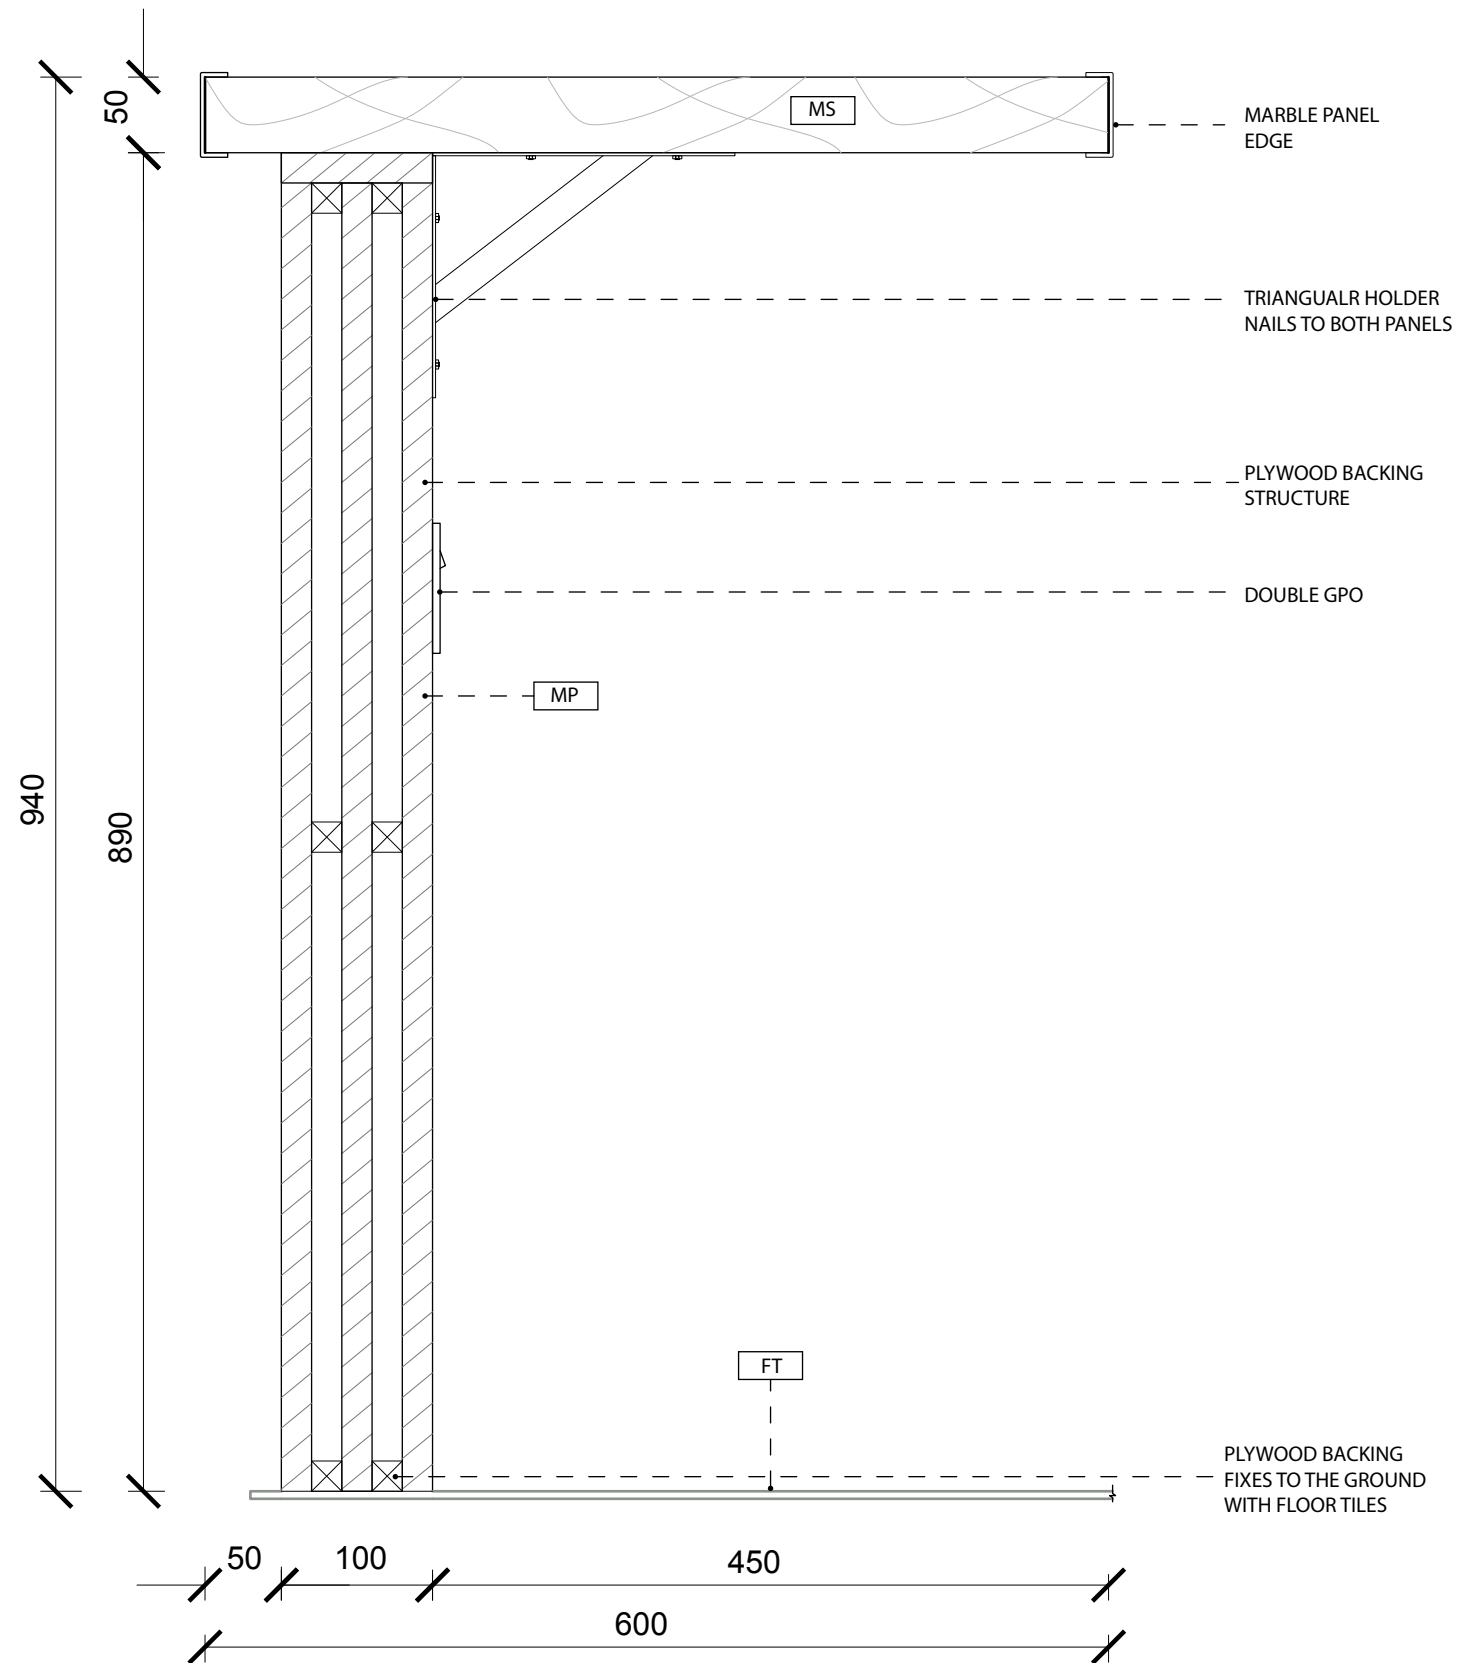


B
A300
DETAILED SECTION 01
1:5

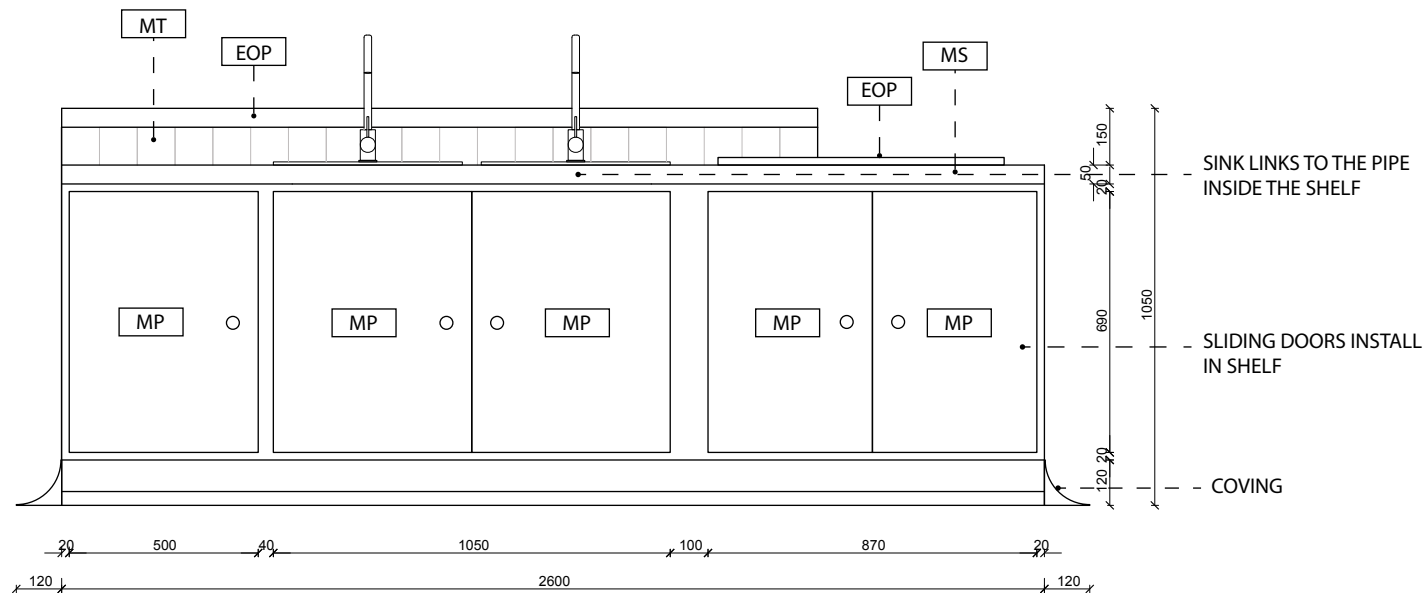


A
A301
DETAILED JOINERY 02 ELEVATION
1:20

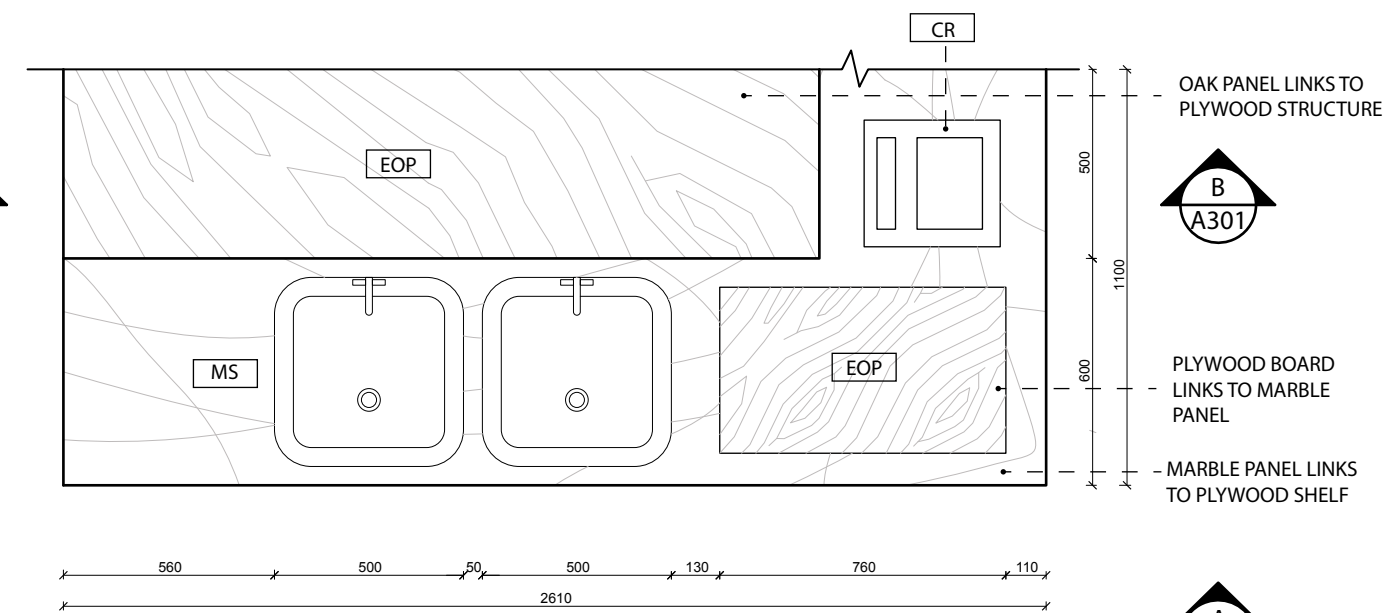


A
A301
DETAILED JOINERY 02 PLAN
1:20

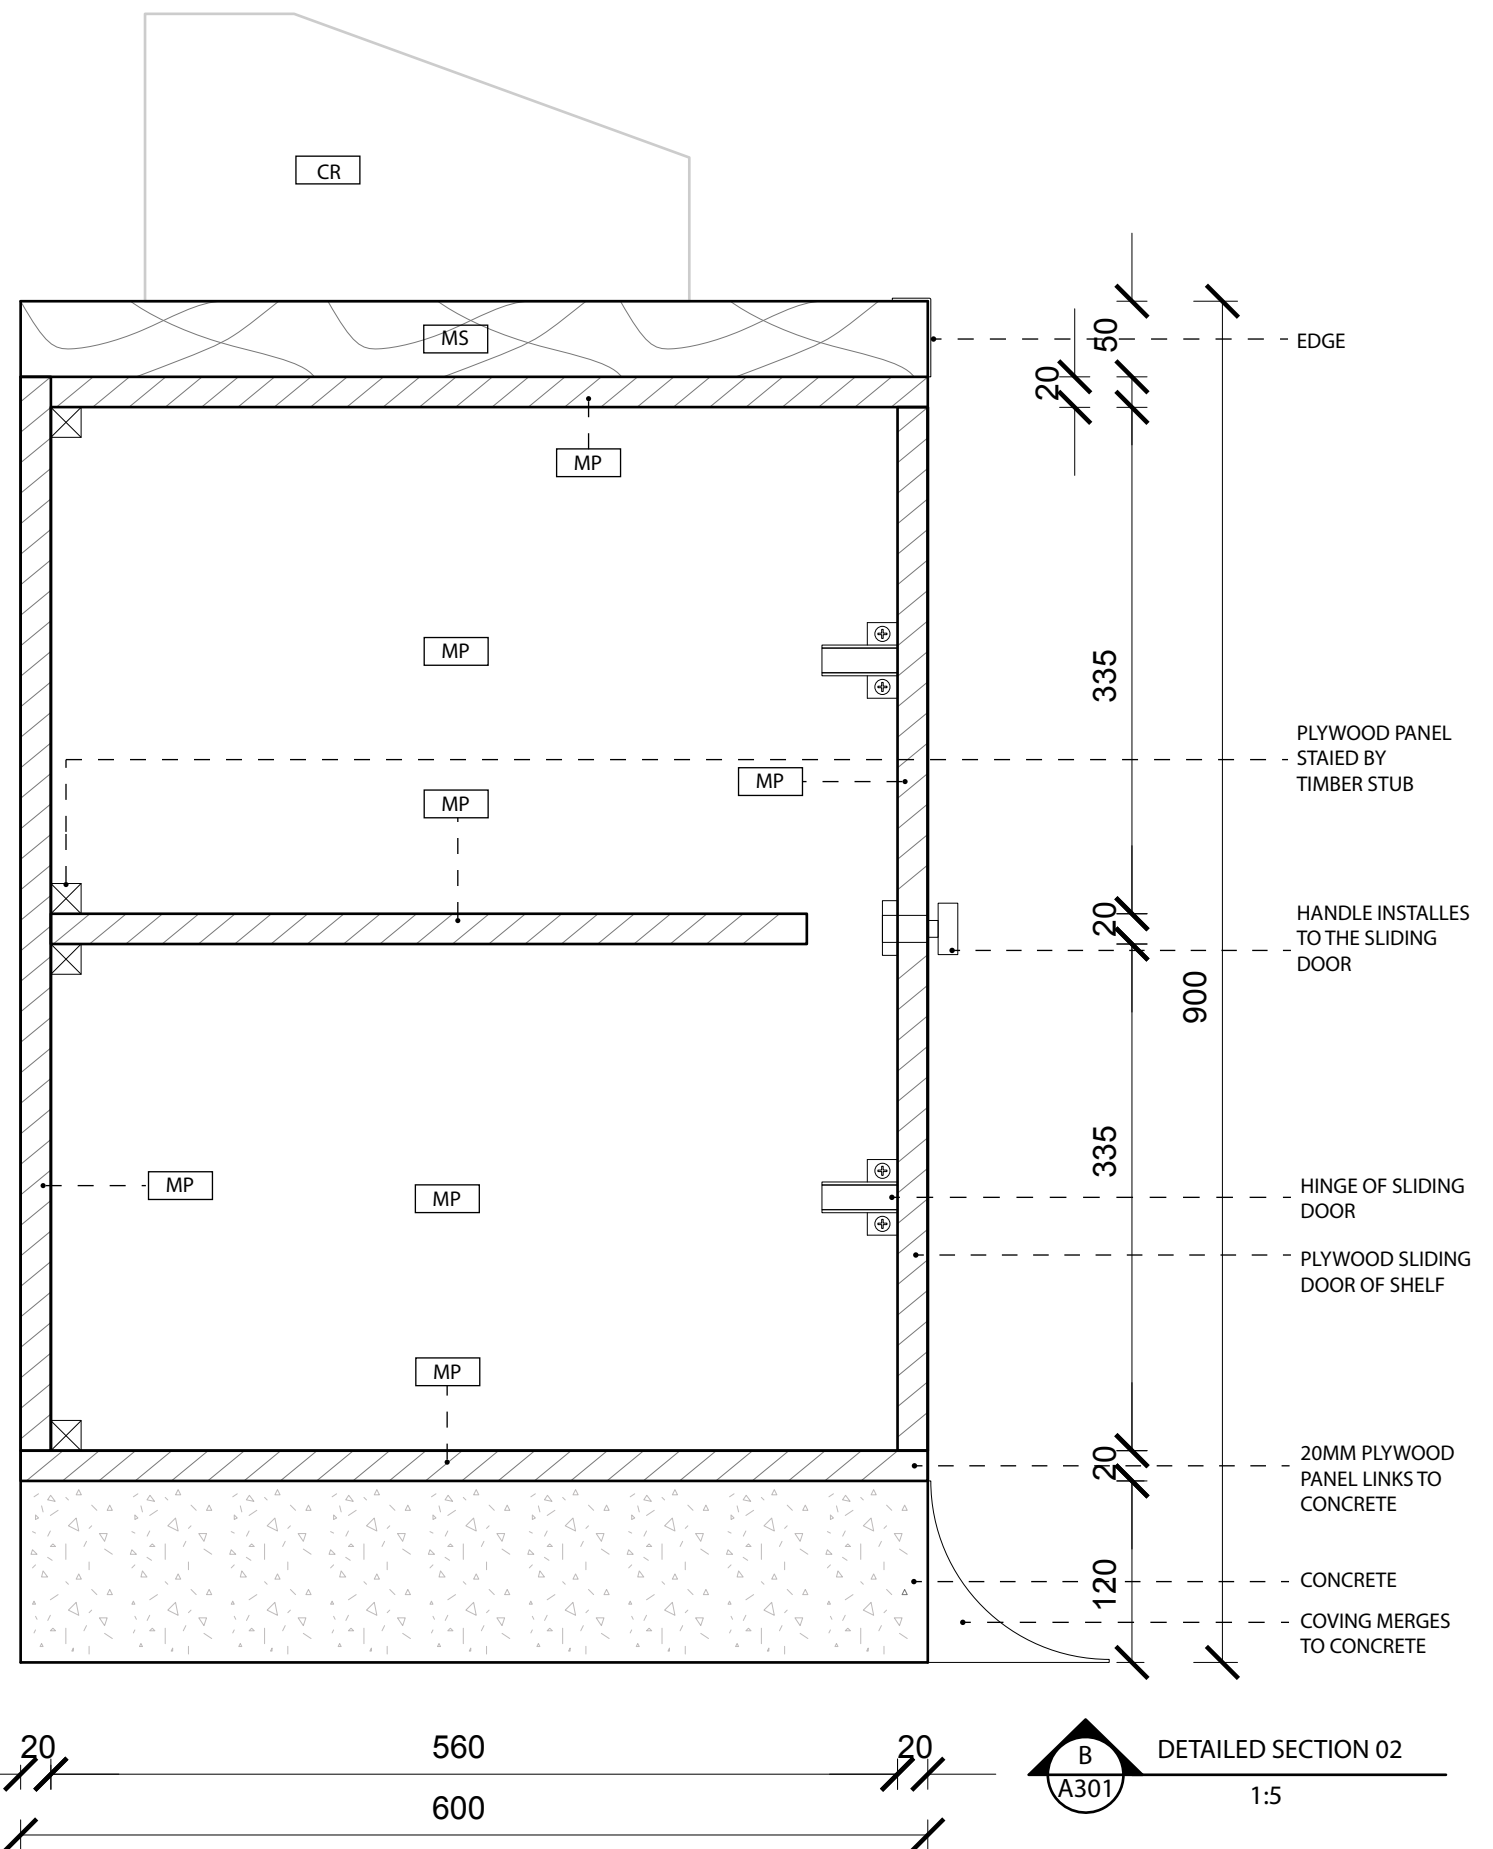


B
A301
DETAILED SECTION 02
1:5

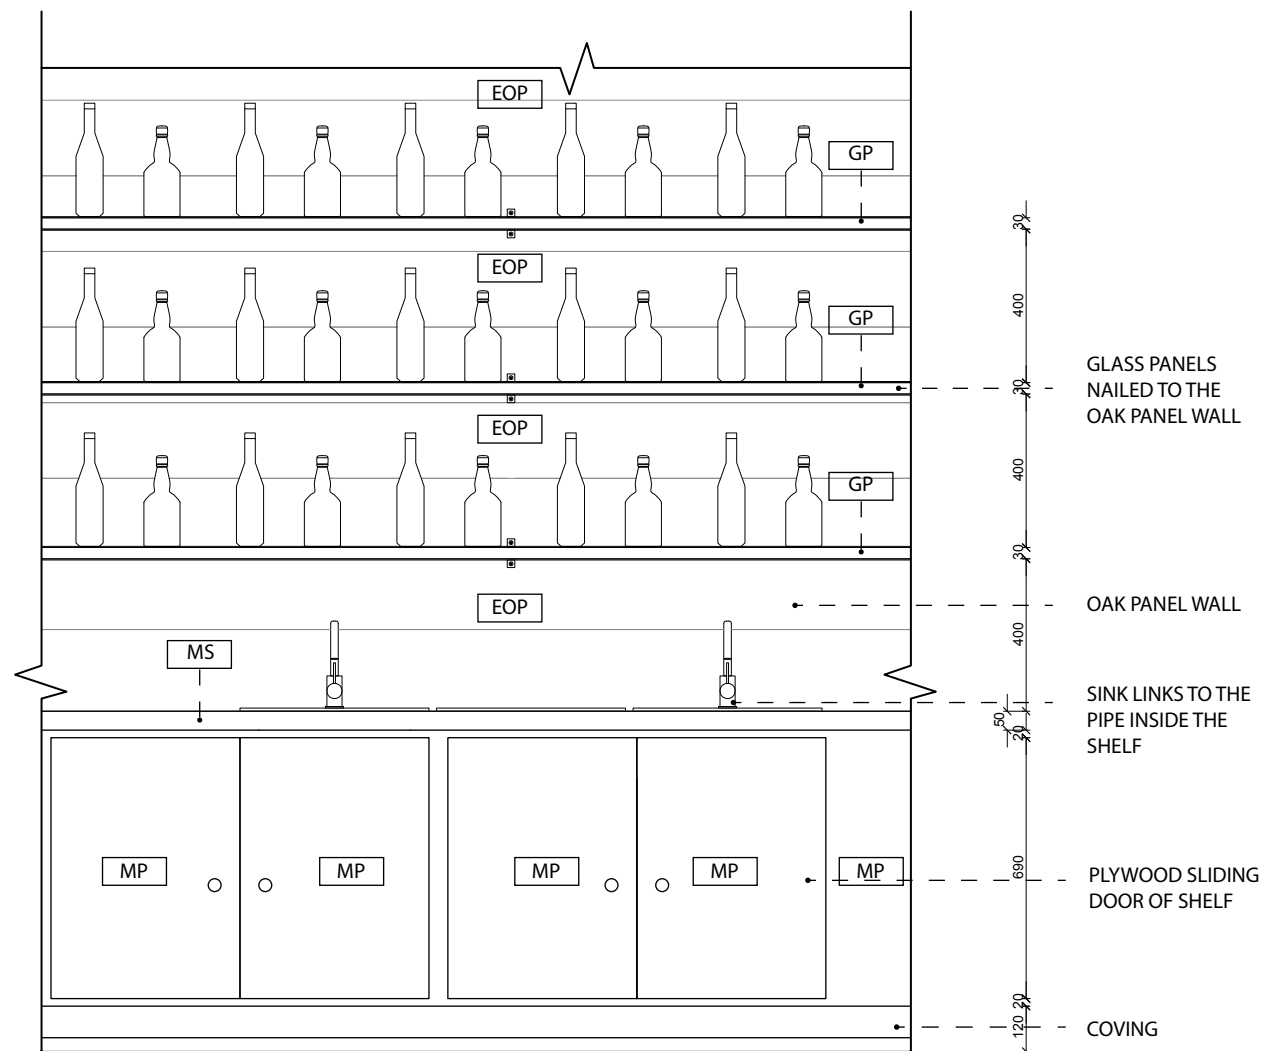


DETAILLED JOINERY 03 ELEVATION
A
A302
1:20

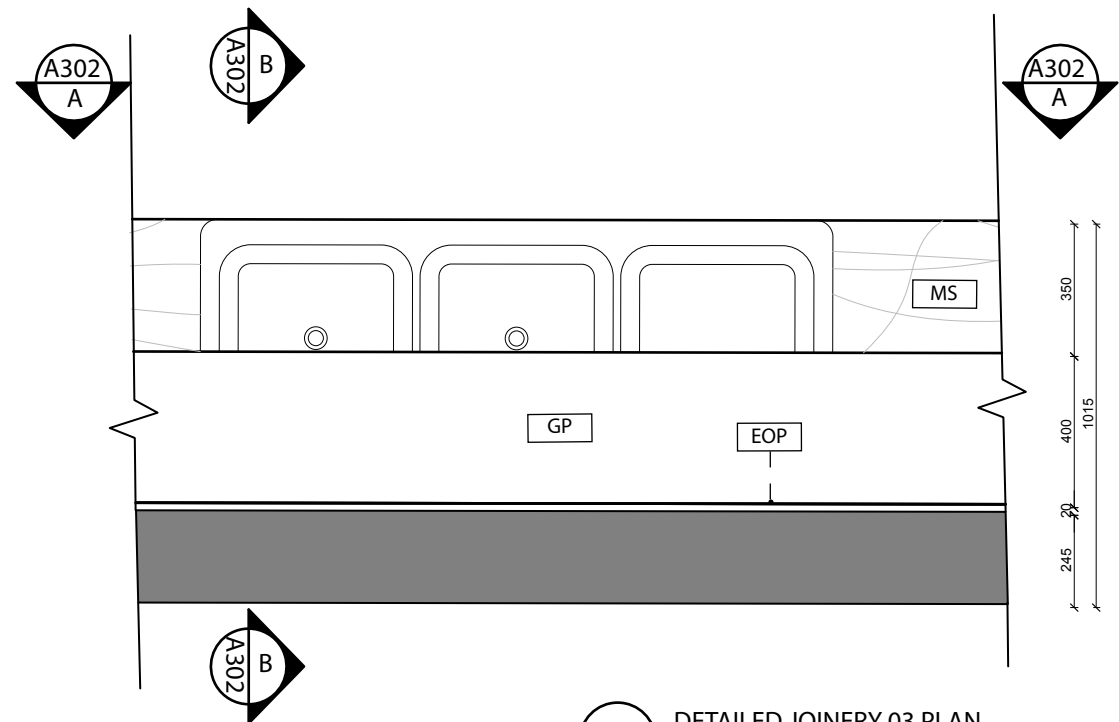

DETAILLED JOINERY 03 PLAN
A302
1:20

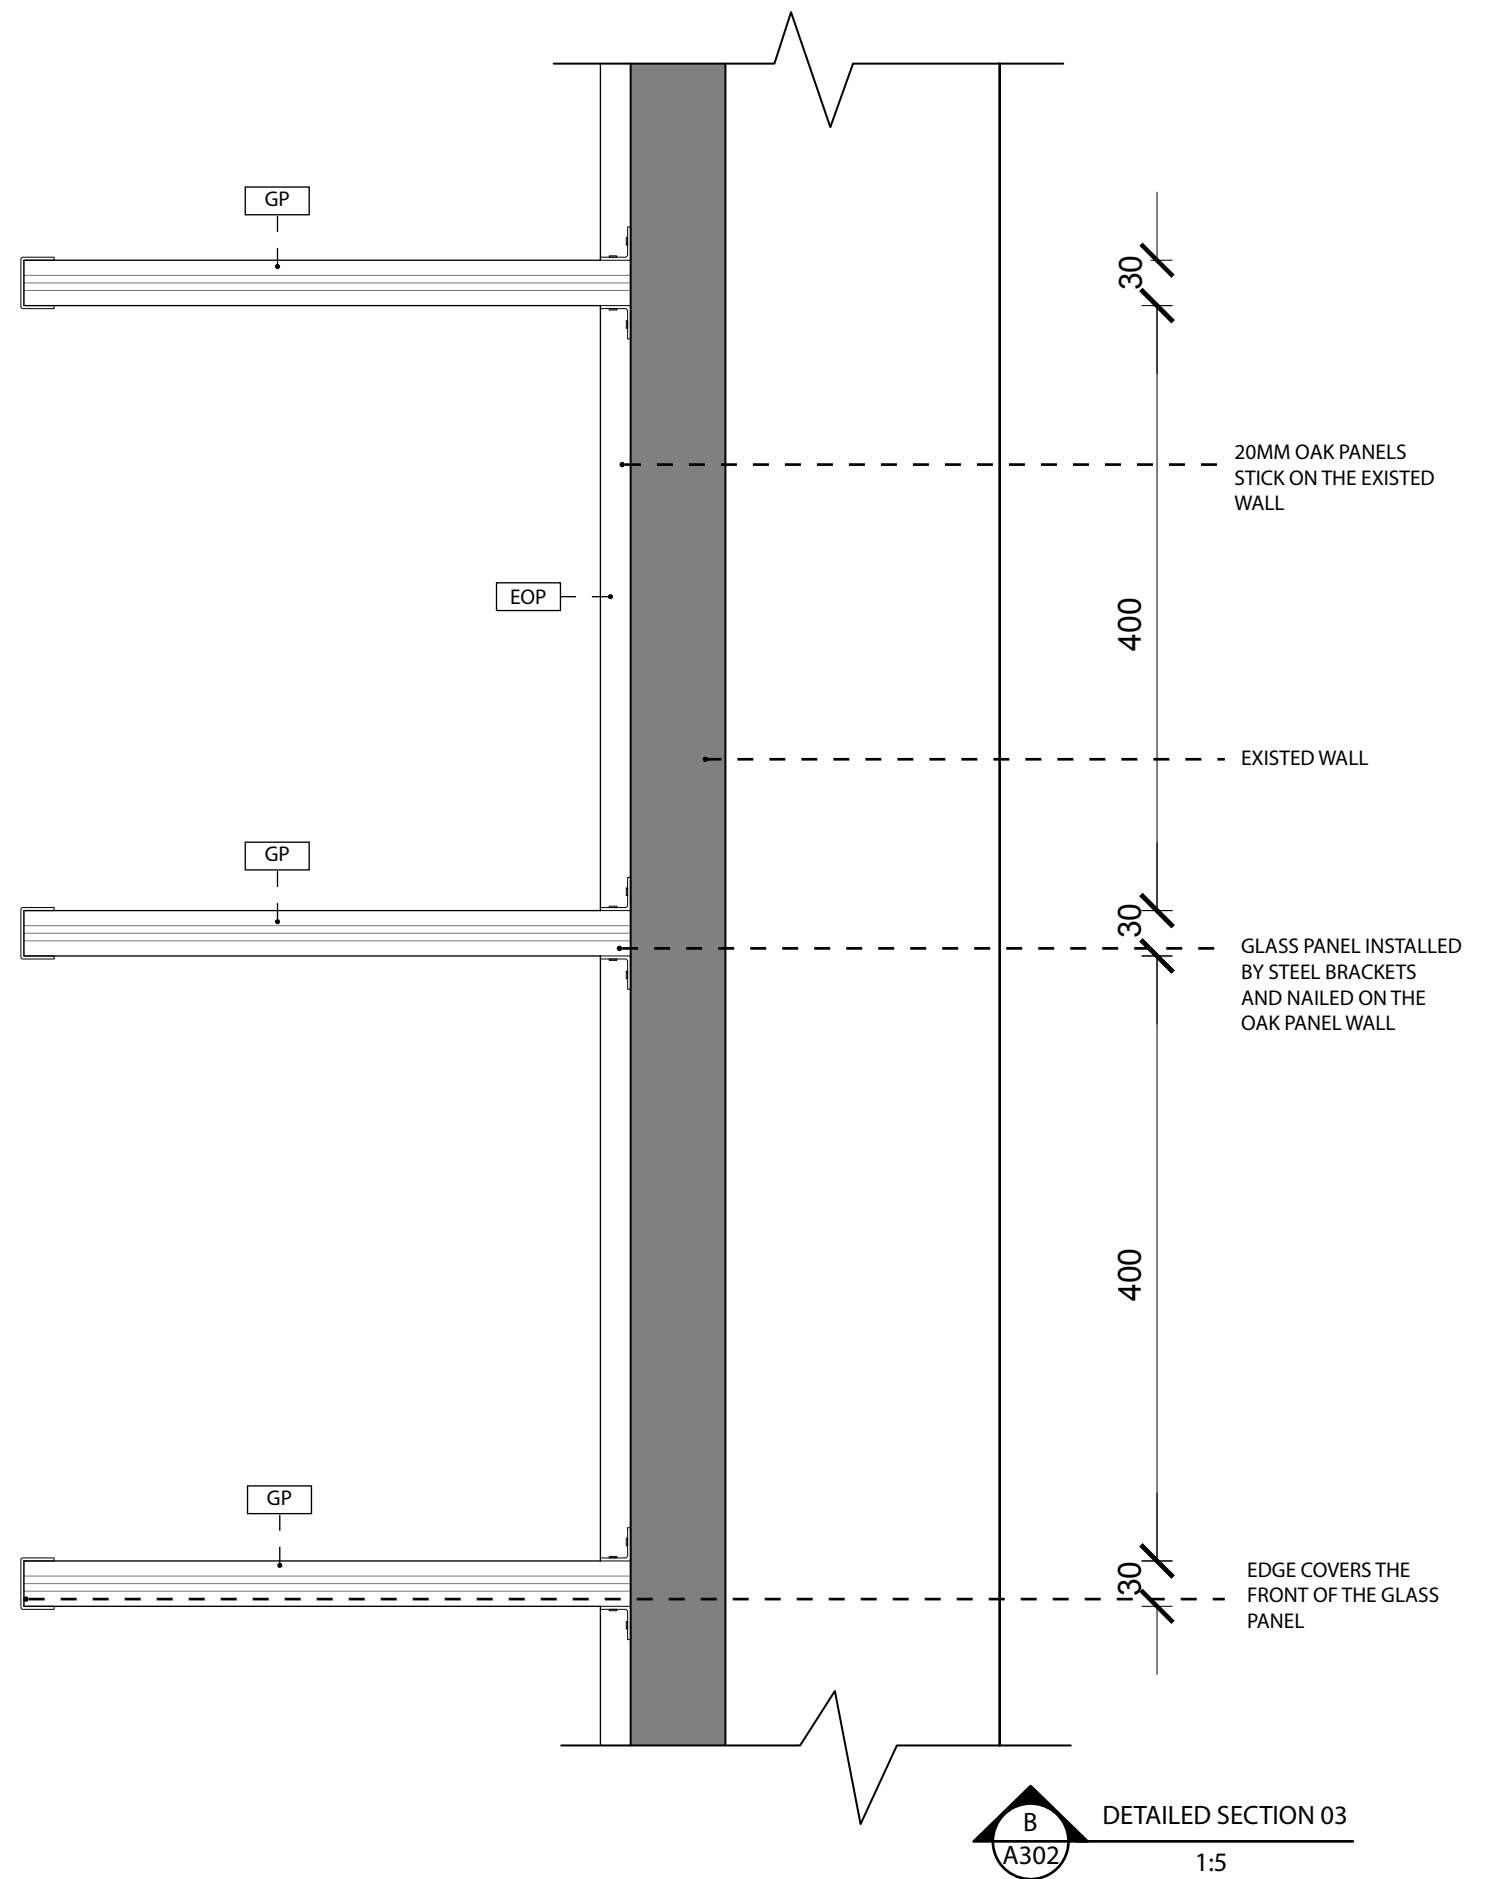

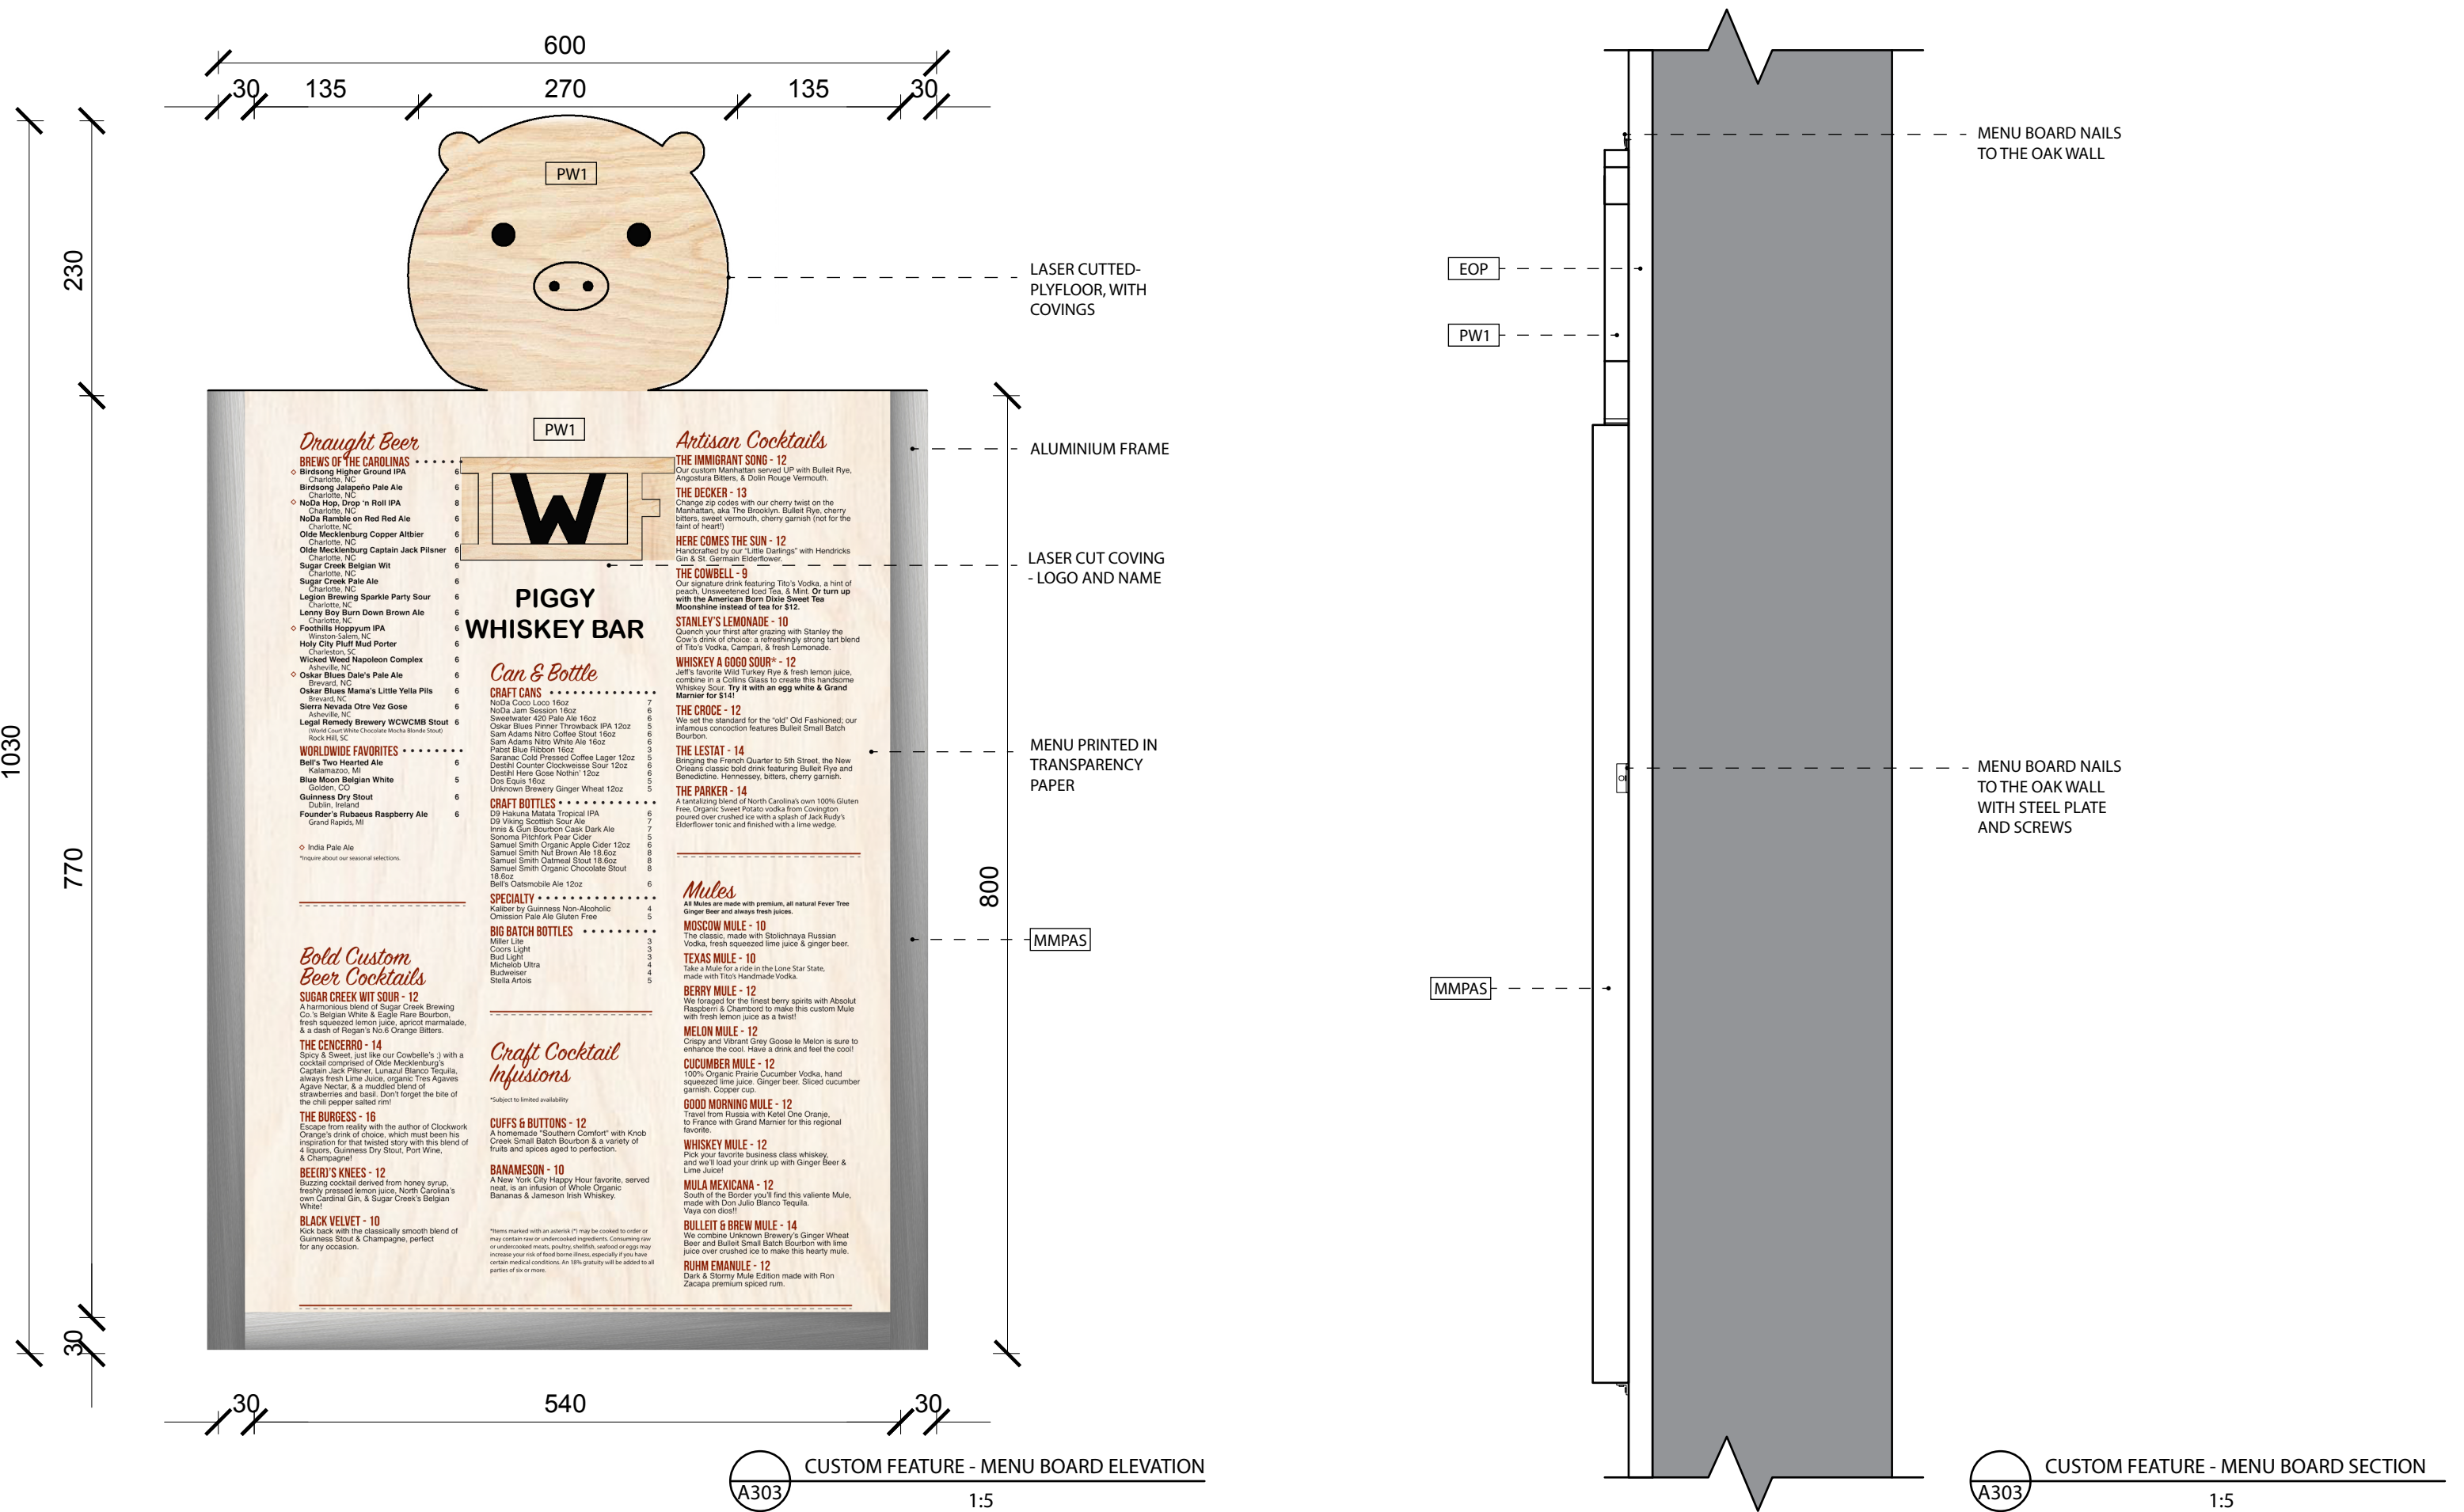







<div><div><div></div><div>UTS</div><div>UNIVERSITY OF TECHNOLOGY SYDNEY</div></div><div>SITE ADDRESS: 704-730 HARRIS St, ULTIMO, NSW 2007</div></div>	<div>GENERAL LEGENDS</div> <div><div></div>WALL</div> <div><div></div>OAK PANEL</div>
---	---



MATERIALS SCHEDULE (A400)

YIHENG FU (WEST)
PROJECT: WHISKEY BAR
DATE: 26 AUG 2018
REV ISSUE: A

CODE	IMAGE	DESCRIPTION	NOTES	SUPPLIER	REV
FT		BRICKLANE TREND	SIZE: 300 * 300 MM FINISH: MATT	CROSBY TILES https://www.crosbytiles.com.au/unglazed/	A
MS		ATLAS GOLD MARBLE	IT IS THE MARBLE WITH COLOURS INCLUDING WHITE AND GOLD SIZE: CUSTOMER SIZE	CEREMIC PROCELAIN NATURAL STONE UNIT 4, 119 MCEVOY ST, ALEXANDRIA, NSW, 2015 PH: (02) 8315 4030 https://www.euronaturalstone.com/product/naturalstone/marble/atlas-gold/	A
MT		BIANCA LUMINOUS POLISHED MARBLE MOSAIC	SIZE: 50 * 50 MM FINISH: MARBLE	MCC 33-35 GREEN ST, BANKSMEADOW, NEW, 2019 PH: (02) 9666 3800 https://www.marbleceramiccorp.com.au/stone-mosaic-tile/1449-bianca-luminous-polished-marble-mosaic-50x50.html	A
GP		HIGH QUALITY 30MM THICKNESS LAMINATED GLASS	THICKNESS: 30 MM SHAPE: CURVE, FLAT TYPE: FLOAT GLASS SIZE: CUSTOMER SIZE	ALIBABA.COM https://www.alibaba.com/product-detail/high-quality-30mm-thickness-laminated-glass_60715143937.html?spm=a2700.7724857.normalList.25.1f7e2236N6BGlb	A
EOP		VOUGEOT EUROPEAN OAK	THE WARM COLOUR PALLET OF VOUGEOT HAS BEEN A SMOKED UV OILED FINISHED GUARANTEEING A WARM FEEL TEXTURE: SMOOTH EDGING: MICRO- BEVEL	ASPIRE FLOORS SUITE 13/9 DANKS ST, WATERLOO, NEW, AUSTRALIA 2017 PH: (02) 9699 1648 https://www.aspirefloors.com.au/products/vougeot/	A
MP		MARINE PLYWOOD	THICKNESS: 20 MM WEIGHT: 35-37 KGS FINISH: GENUINE MAHOGANY SIZE: CUSTOMER SIZE	MPW 26 BURROWS RD, ALEXANDRIA, NEW, AUSTRALIA PH: (02) 95505356 http://www.misterplywood.com.au/Products/Plywood/Marine-Plywood	A





MATERIALS SCHEDULE 2
(A400)

YIHENG FU (WEST)
PROJECT: WHISKEY BAR
DATE: 26 AUG 2018
REV ISSUE: A

CODE	IMAGE	DESCRIPTION	NOTES	SUPPLIER	REV
PW1		ECOPLY PLYFLOOR STRUCTURAL FLOORING	PLYFLOOR IS A STRONG, DURABLE PRE-SANDED PANEL SUTABLE FOR STRUCTURAL AND NON-STRUCTURAL FLOORING IN RESIDENTIAL, COMMERCIAL AND INDUSTRIAL APPLICATIONS, PARTICULAR WHERE ADDED STRENGTH IS REQUIRED	BUNNINGS WAREHOUSE https://www.bunnings.com.au/ecoply-2400-x-1200-x-17mm-plyfloor-structural-flooring_p0390075	A
MMPAS		METAL MATE PLAIN ALUMINIUM SHEET	CONVENIENT PRE- CUT SIZES AND LIGHTWEIGHT MILL FINISH EASY TO CUT, DRILL, RIVET, SCREW AND FOLD	BUNNINGS WAREHOUSE https://www.bunnings.com.au/metal-mate-0-5-x-900-x-900mm-plain-aluminium-sheet_p1117024	A

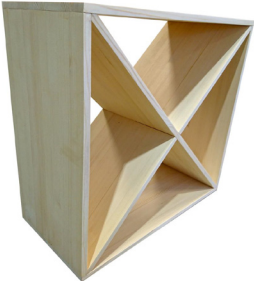


**FURNITURE SCHEDULE
(A401)**

YIHENG FU (WEST)
PROJECT: WHISKEY BAR
DATE: 26 AUG 2018
REV ISSUE: B

CODE	IMAGE	DESCRIPTION	NOTES	SUPPLIER	QUANTITY	REV
R1		<p>WINE CUBES</p> <p>STORE, AGE AND DISPLAY WINE IN WINE RACK</p> <p>DESIGNED TO ACCOMMODATE UP TO 24 BOTTLES OF WINE IN A UNIQUE DIAMOND PATTERN. ENGINEERED WITH SUSTAINABLY SOURCED TIMBER AND STURDY STEEL COMPONENTS THESE CUBE WINE RACK ARE DESIGNED TO LAST A LIFETIME, DUE TO THEIR SQUARE SHAPE, MULTIPLE UNITS CAN BE EFFORTLESSLY STACKED TOGETHER TO CREATE A FEATURE WALL</p>	<p>FULLY ASSESMBLED MEASUREMENTS:</p> <p>LENGTH: 60 CM WIDTH: 30 CM HEIGHT: 60CM</p> <p>WITH A TOTAL CAPACITY OF 24 BOTTLES WINE</p>	<p>WINE STASH</p> <p>https://winestash.com.au/products/wine-cubes</p>	2	B
R2		<p>HANGIN GLASS RACK</p> <p>THE WINE GLASS RACK IS IDEAL FOR STORING WINE GLASSES OR CHAMPAGNE FLUTES IN THE KITCHEN.THE GLASSES HOLDER IS MADE FROM COMPRESSED AND GLUED NATURAL BAMBOO BARS, GLASSESS HOLDER HAS HOLES FOR FIXING IT UNDERNEATH A SHELF, CUPBOARD OR KITCHEN HANGING UNIT, THE WINE GLASS RACK HOLDS UP TO 20 GLASSESS, AND THE WINES CAN STORE 5 BOTTLES</p>	<p>MEASUREMENTS:</p> <p>LENGTH: 525 MM WIDTH: 305 MM HEIGHT: 45 MM</p>	<p>FINOAK.COM</p> <p>https://finoak.com/products/SKU1448-Hanging-Glass-Rack#dimensions</p>	6	B
S		<p>OSLO BAR STOOL (WALNUT, BLACK)</p> <p>DANISH INSPIRED DESIGN, POWER COATED, SOILD ASH TIMBER, FOOT BAR FOR COMFORT, WIPE CLEAN AND DUST WITH A SOFT DAMP CLOTH</p>	<p>MEASUREMENTS:</p> <p>LENGTH: 42.8 CM WIDTH: 42.8 CM HEIGHT: 66 CM</p>	<p>LIFEINTERIORS.COM.AU</p> <p>505 BALMAIN RD, LILYFIELD, NSW 2040</p> <p>PH: 1300544899</p> <p>https://www.lifeinteriors.com.au/design-by-life-oslo-bar-stool-walnut</p>	10	B
CR		<p>CASIO SEC450 ECR CASH REGISTER</p> <p>THIS MACHINE HAS A LARGE TILTING MULTI-LINE LCD OPERATOR DISPLAY, THIS MODEL HAS A SINGLE THERMAL RECEIPT PRINTER 72 FLAT DEPARTMENT/PLU KEYS ON BOARD AND COMES IN BLACK WITH A FULL-SIZED METAL CASH DRAWER AND 2000 BARCODE PRODUCT MEMORY</p>		<p>ONLYPOS</p> <p>SUITE 303, 3 RICHARDSON PLACE, NORTH RYDE, NSW 2113, AUSTRALIA</p> <p>PH: 1300183340</p> <p>https://www.onlypos.com.au/casio-sec450-cash-register</p>	1	B

LIGHT SCHEDULE
(A402)

YIHENG FU (WEST)
PROJECT: WHISKEY BAR
DATE: 26 AUG 2018
REV ISSUE: B

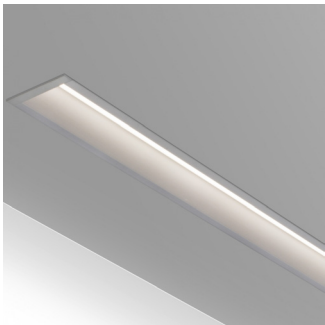CODE	IMAGE	DESCRIPTION	NOTES	SUPPLIER	QUANTITY	REV
A1		RECESSED FULLY ADJUSTABLE DOWNLIGHT, 13W LED, 24 DEGREE BEAM WIDTH, CRI>80, 4500 COLOUR TEMPERSTURE. COMPLETE WITH DIMABLE GEAR. COLOUR: WHITE TO MATCH THE WALL AND CEILING COLOUR	COLOUR: 4500K TEMP	ECC LIGHTING WATERLOO DESIGN CENTRE SUITES 102 + 205, LVEL 1 197 YOUNG STREET WATERLOO, NEW, 2017 PH:61293180833	13	B
B		TRACK MOUNTED FULLY ADJUSTABLE SPOTLIGHT FITTING, 22W LED, 24 DEGREE BAND WIDTH, CRI>80, 3500K COLOUR TEMPERATURE, COMPLETE TE WITH DIMABLE GEAR. COLOUR: WHITE TO MATCH THE CEILING	COLOUR: 3500K TEMP	ECC LIGHTING WATERLOO DESIGN CENTRE SUITES 102 + 205, LVEL 1 197 YOUNG STREET WATERLOO, NEW, 2017 PH:61293180833	7	B
W		RECESSED WALL WASH LIGHT, 13W, 60 DEGREE BEAM WIDTH, CRI>60, 6000K COLOUR TEMPERATURE, COMPLETE WITH A SIGHT DIMABLE GEAR	COLOUR: 4000K – 12000K TEMP CONTROL VIA WIRELESS REMOTE	ECC LIGHTING WATERLOO DESIGN CENTRE SUITES 102 + 205, LVEL 1 197 YOUNG STREET WATERLOO, NEW, 2017 PH:61293180833	5	B